




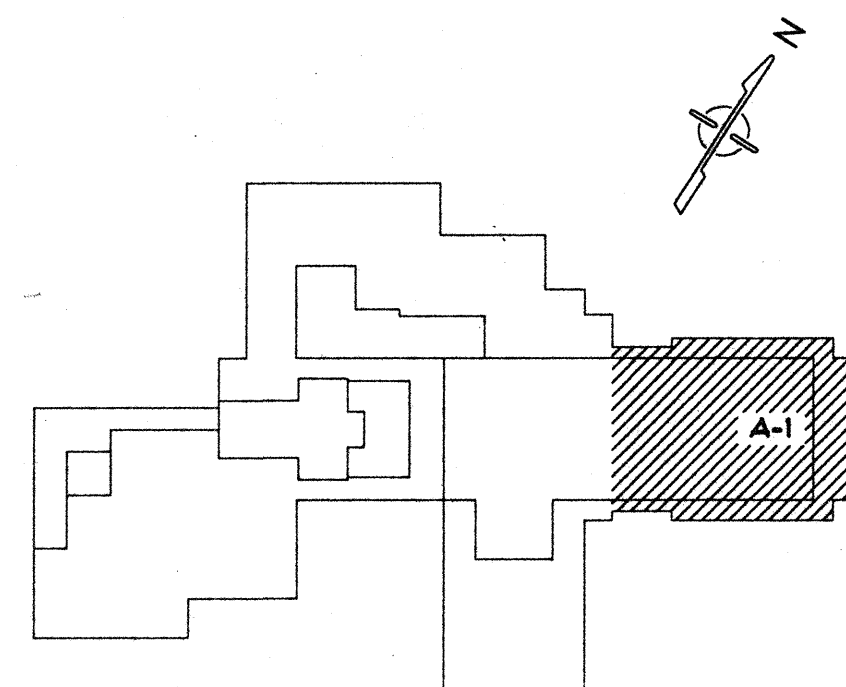

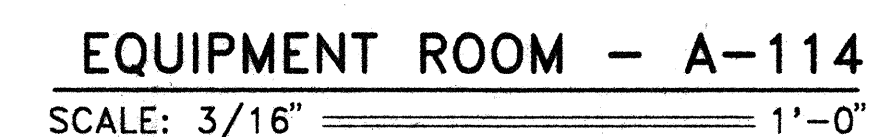

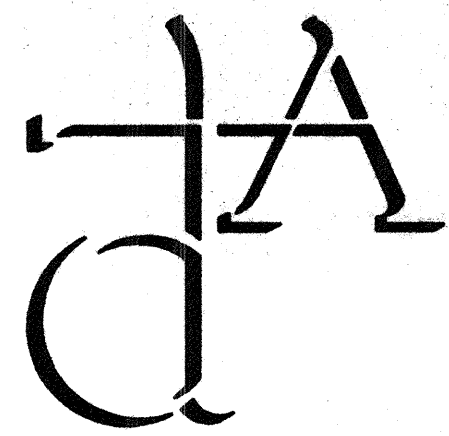

Drakeford Architects

120 North Main Street  
Sumter SC 29150 803 775-6587

Date April 93

Revisions

Waccamaw  
CMHS Central  
Facility


Horry County, S.C.

Project No. J12-9544-PM

Heating and Air  
Conditioning


Floor Plan -  
A-2 Wing

Scale: 3/16" = 1'-0"

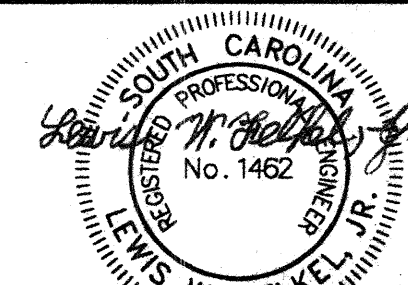


FELKEL & HASTINGS  
Mechanical Engineers  
2740 Devine Street  
Columbia, S.C. 29205  
Comm. No.: 1494 Date: 3-29-93

Sheet M-2 of 11

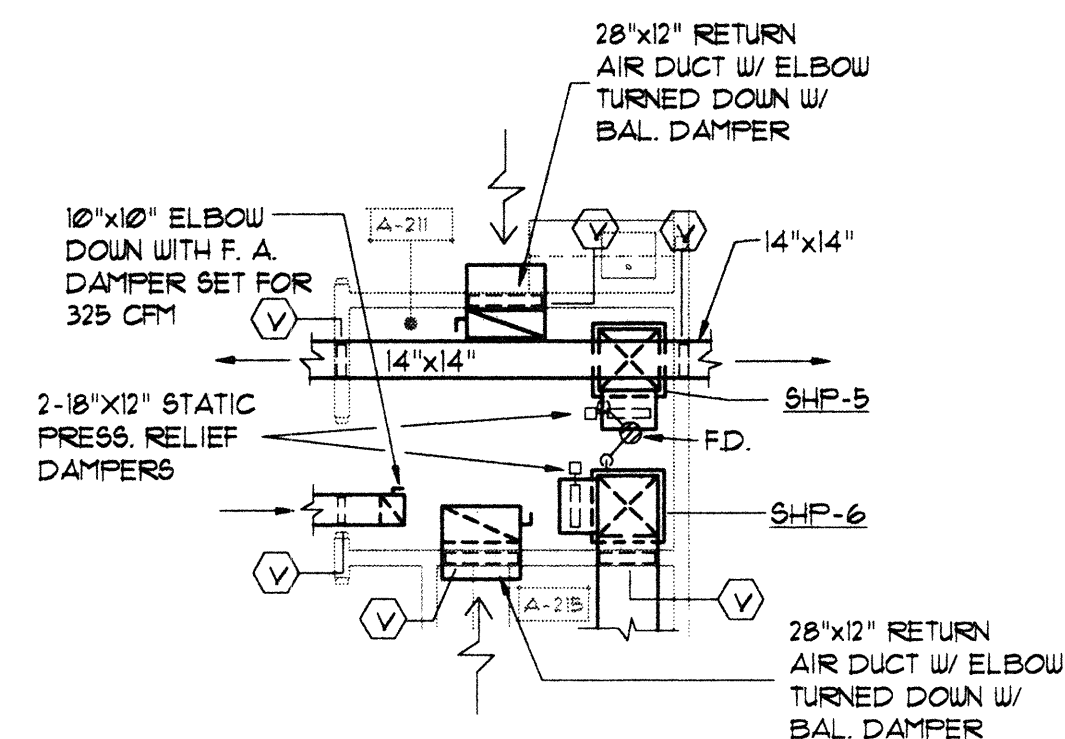


EQUIPMENT ROOM - A-211  
SCALE: 3/16" = 1'-0"

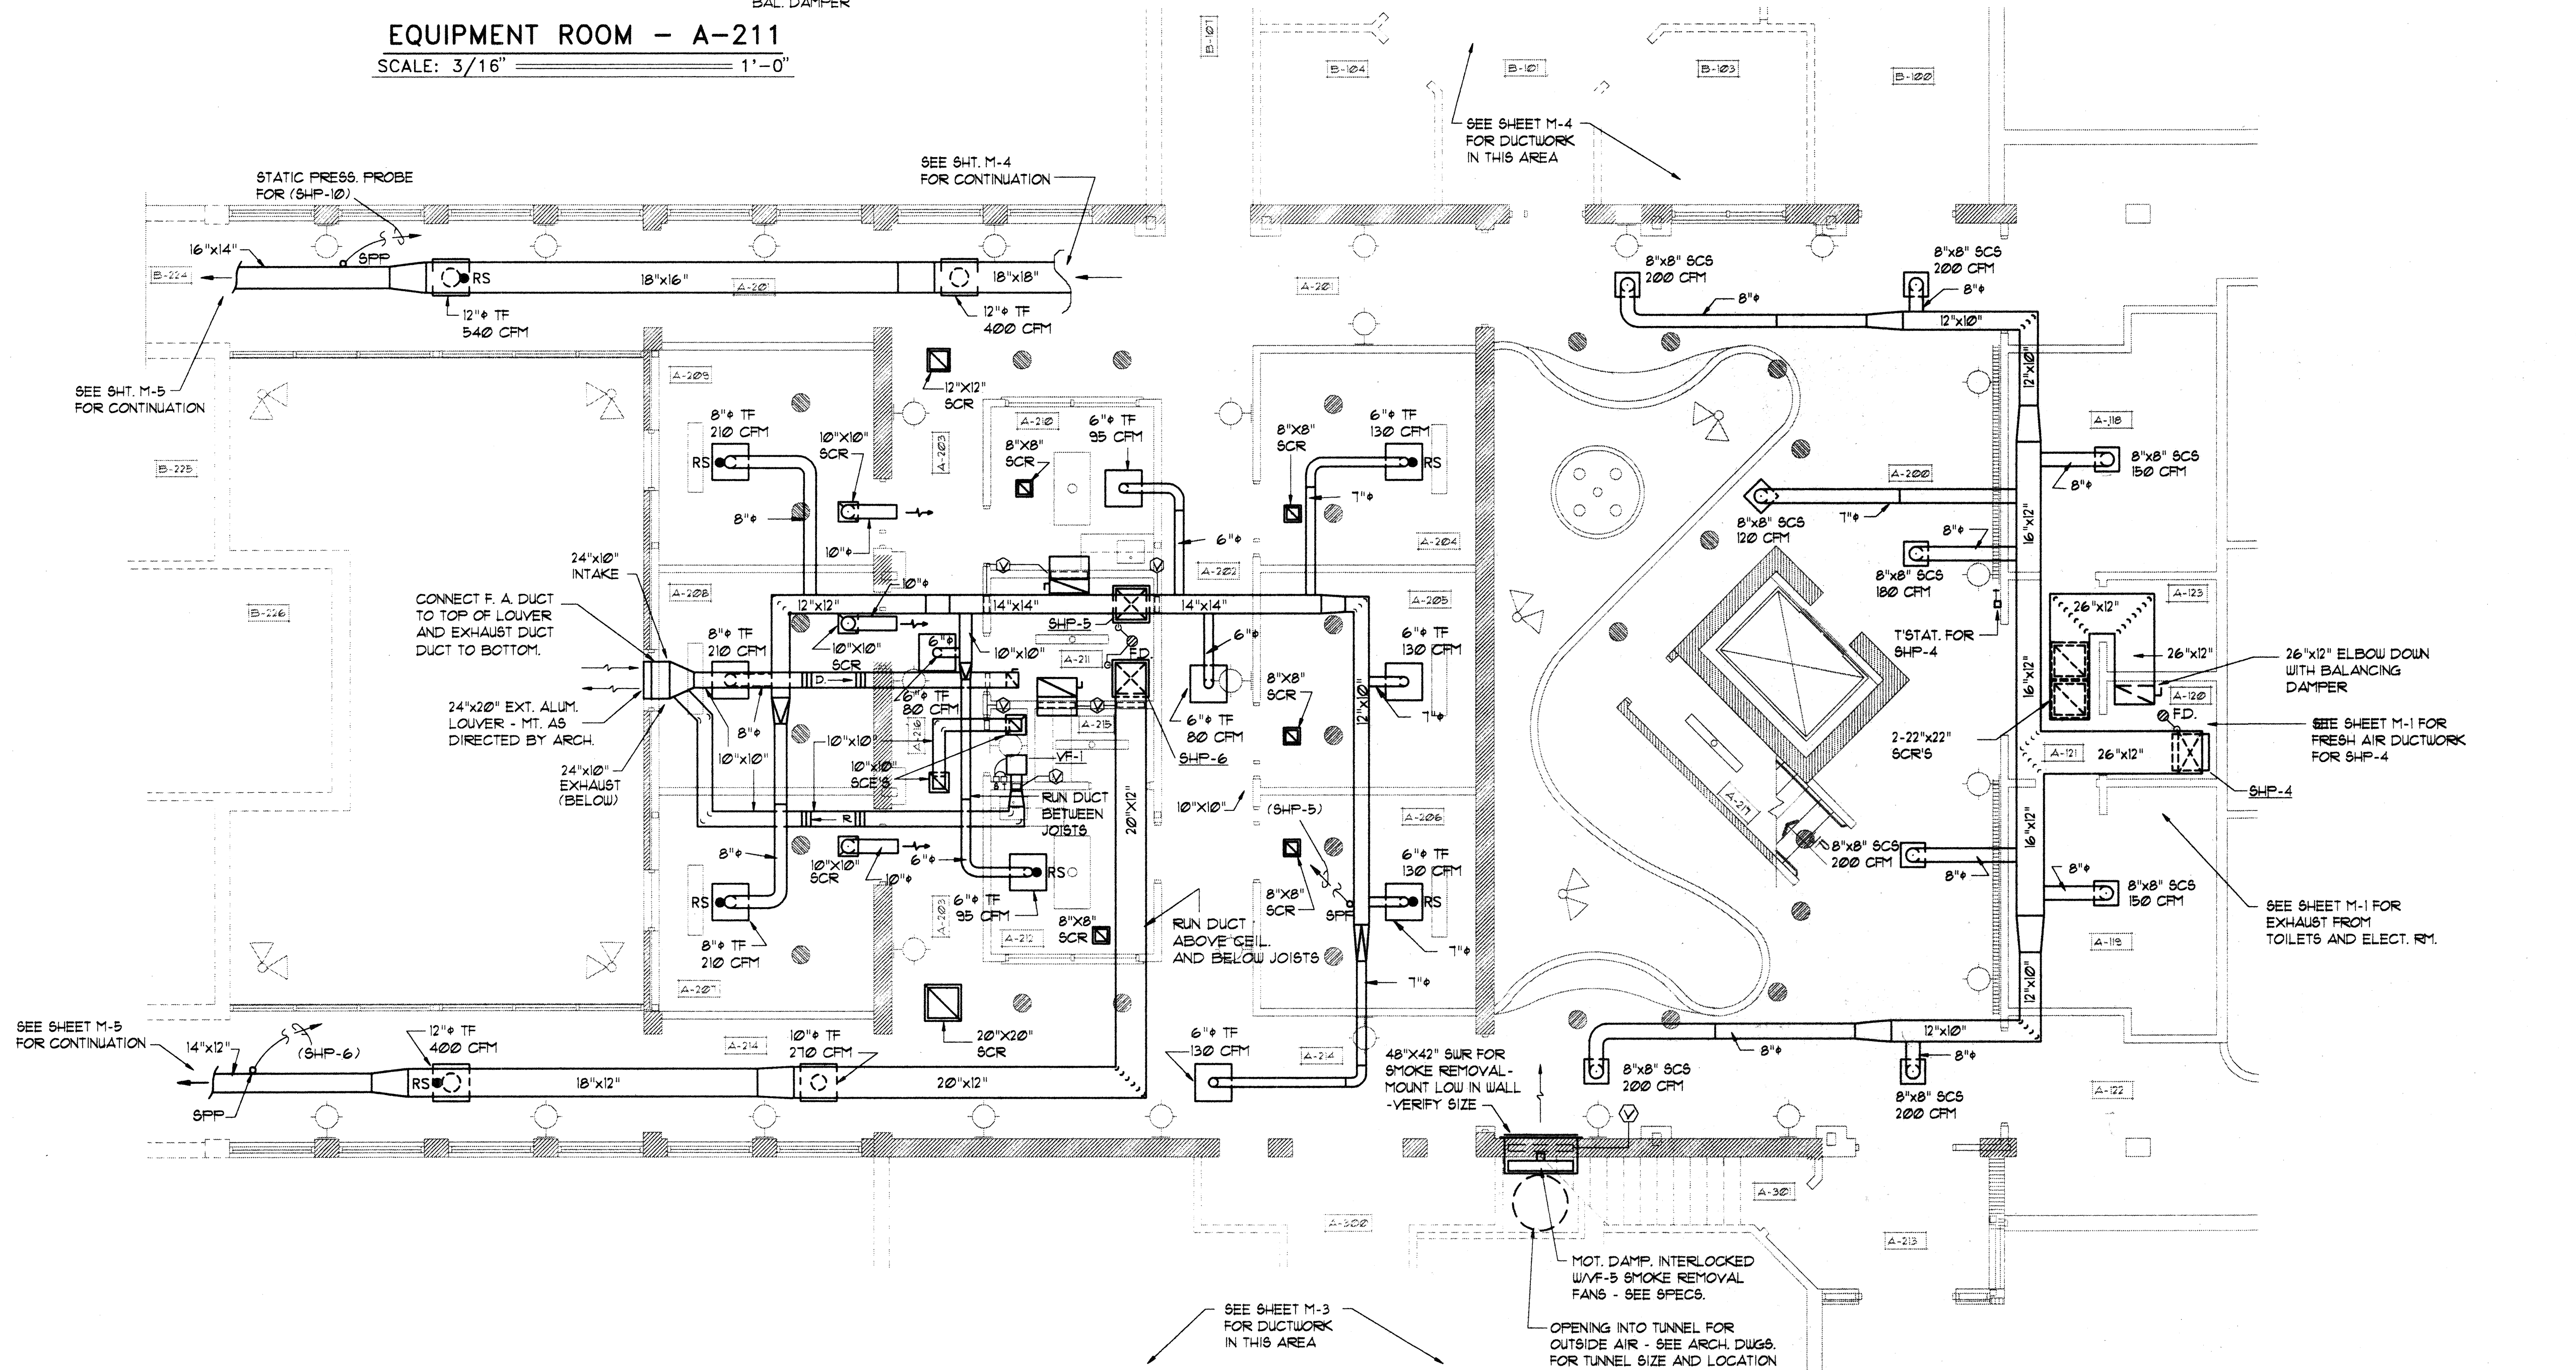


FIRST FLOOR - A-2 WING  
HEATING AND AIR CONDITIONING PLAN

SCALE: 3/16" = 1'-0"

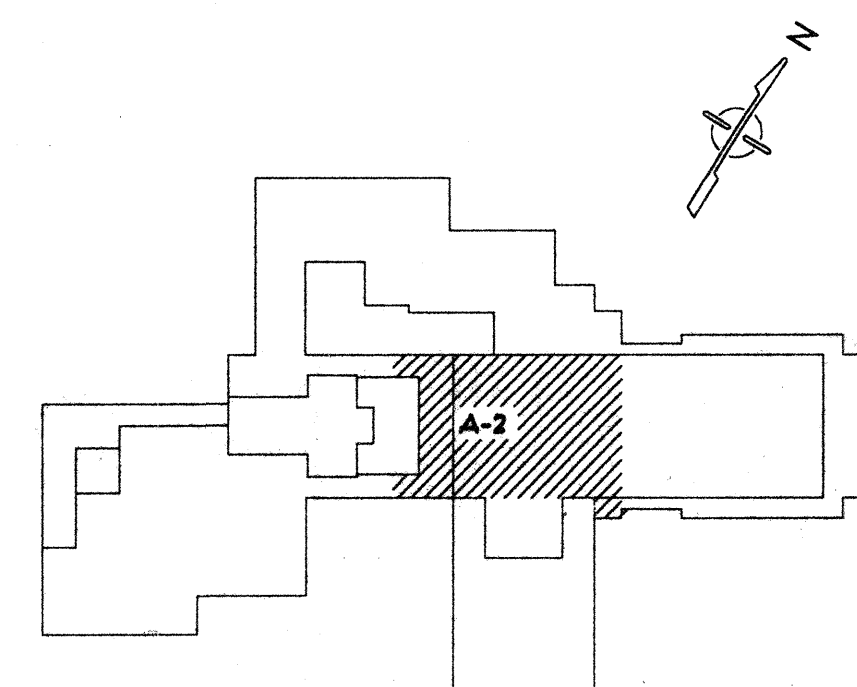



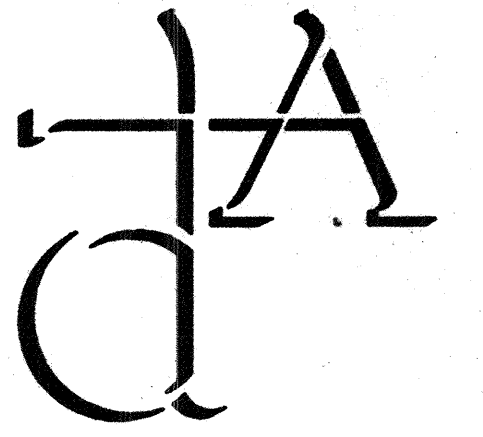

Drakeford Architects

120 North Main Street  
Sumter SC 29150 803 775-6567

Date April 93

Revisions

Waccamaw  
CMHS Central  
Facility


Horry County, S.C.

Project No. J12-9544-PM

Heating and Air  
Conditioning


Floor Plan -  
A-3 Wing

Scale: 3/16" = 1'-0"

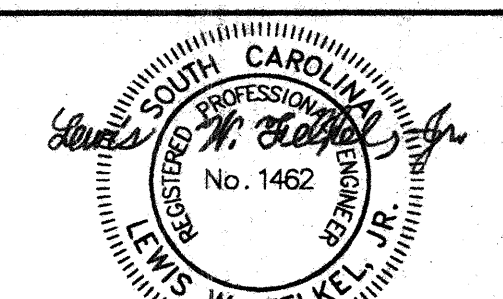


FELKEL & HASTINGS  
Mechanical Engineers  
2740 Devine Street  
Columbia, S.C. 29205  
Comm. No.: 1494 Date: 3-29-93

Sheet M-3 of 11

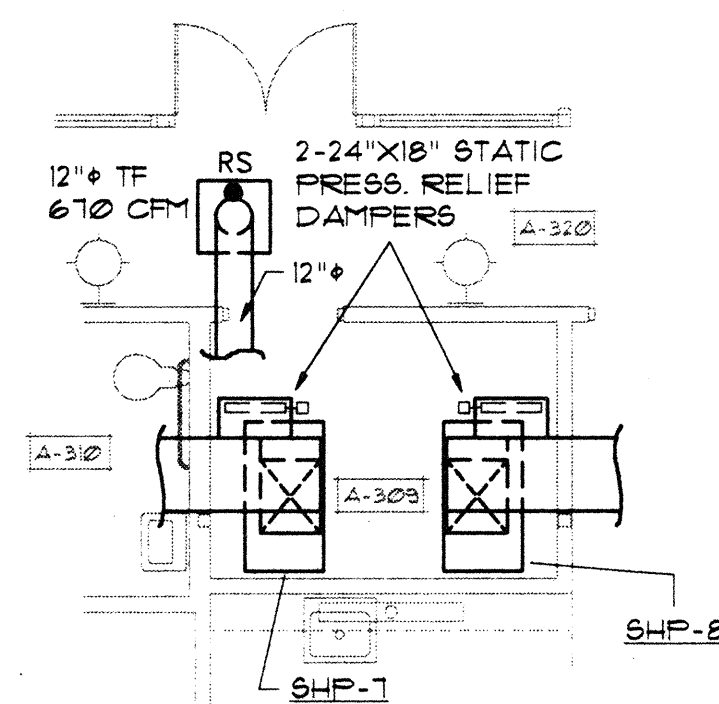


EQUIPMENT ROOM - A-309  
SCALE: 3/16" = 1'-0"

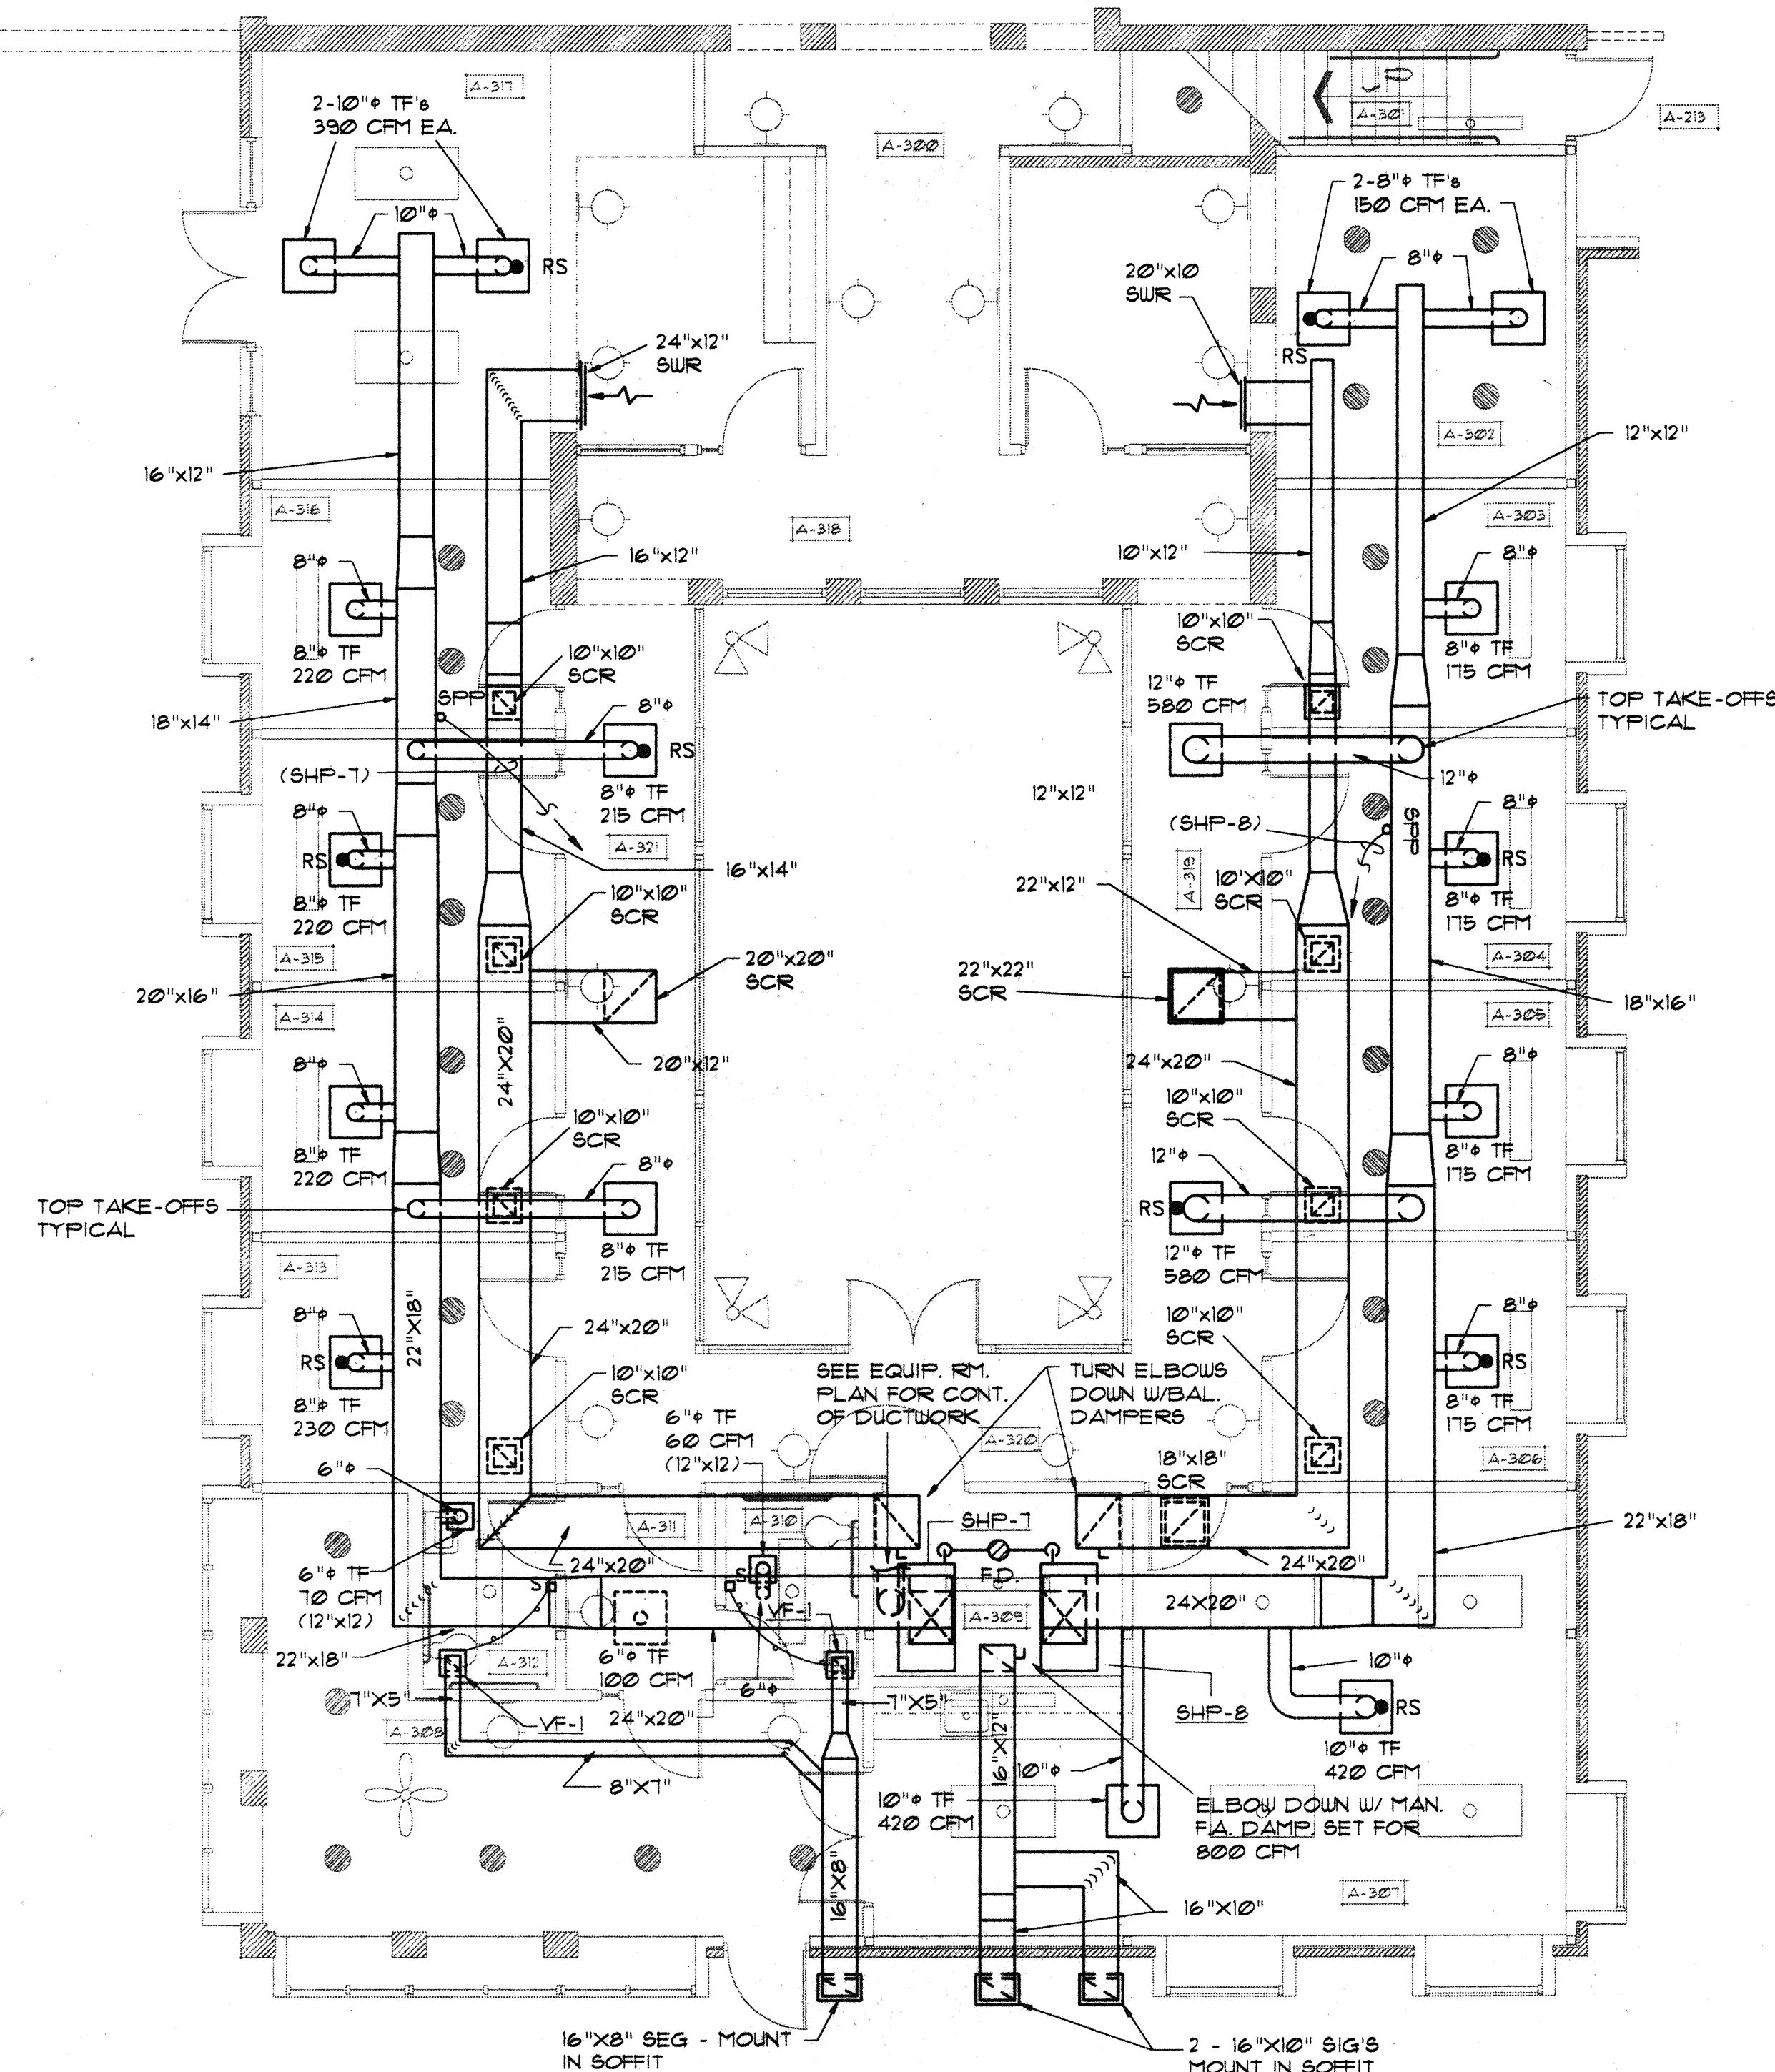


FIRST FLOOR - A-3 WING  
HEATING AND AIR CONDITIONING PLAN  
SCALE: 3/16" = 1'-0"




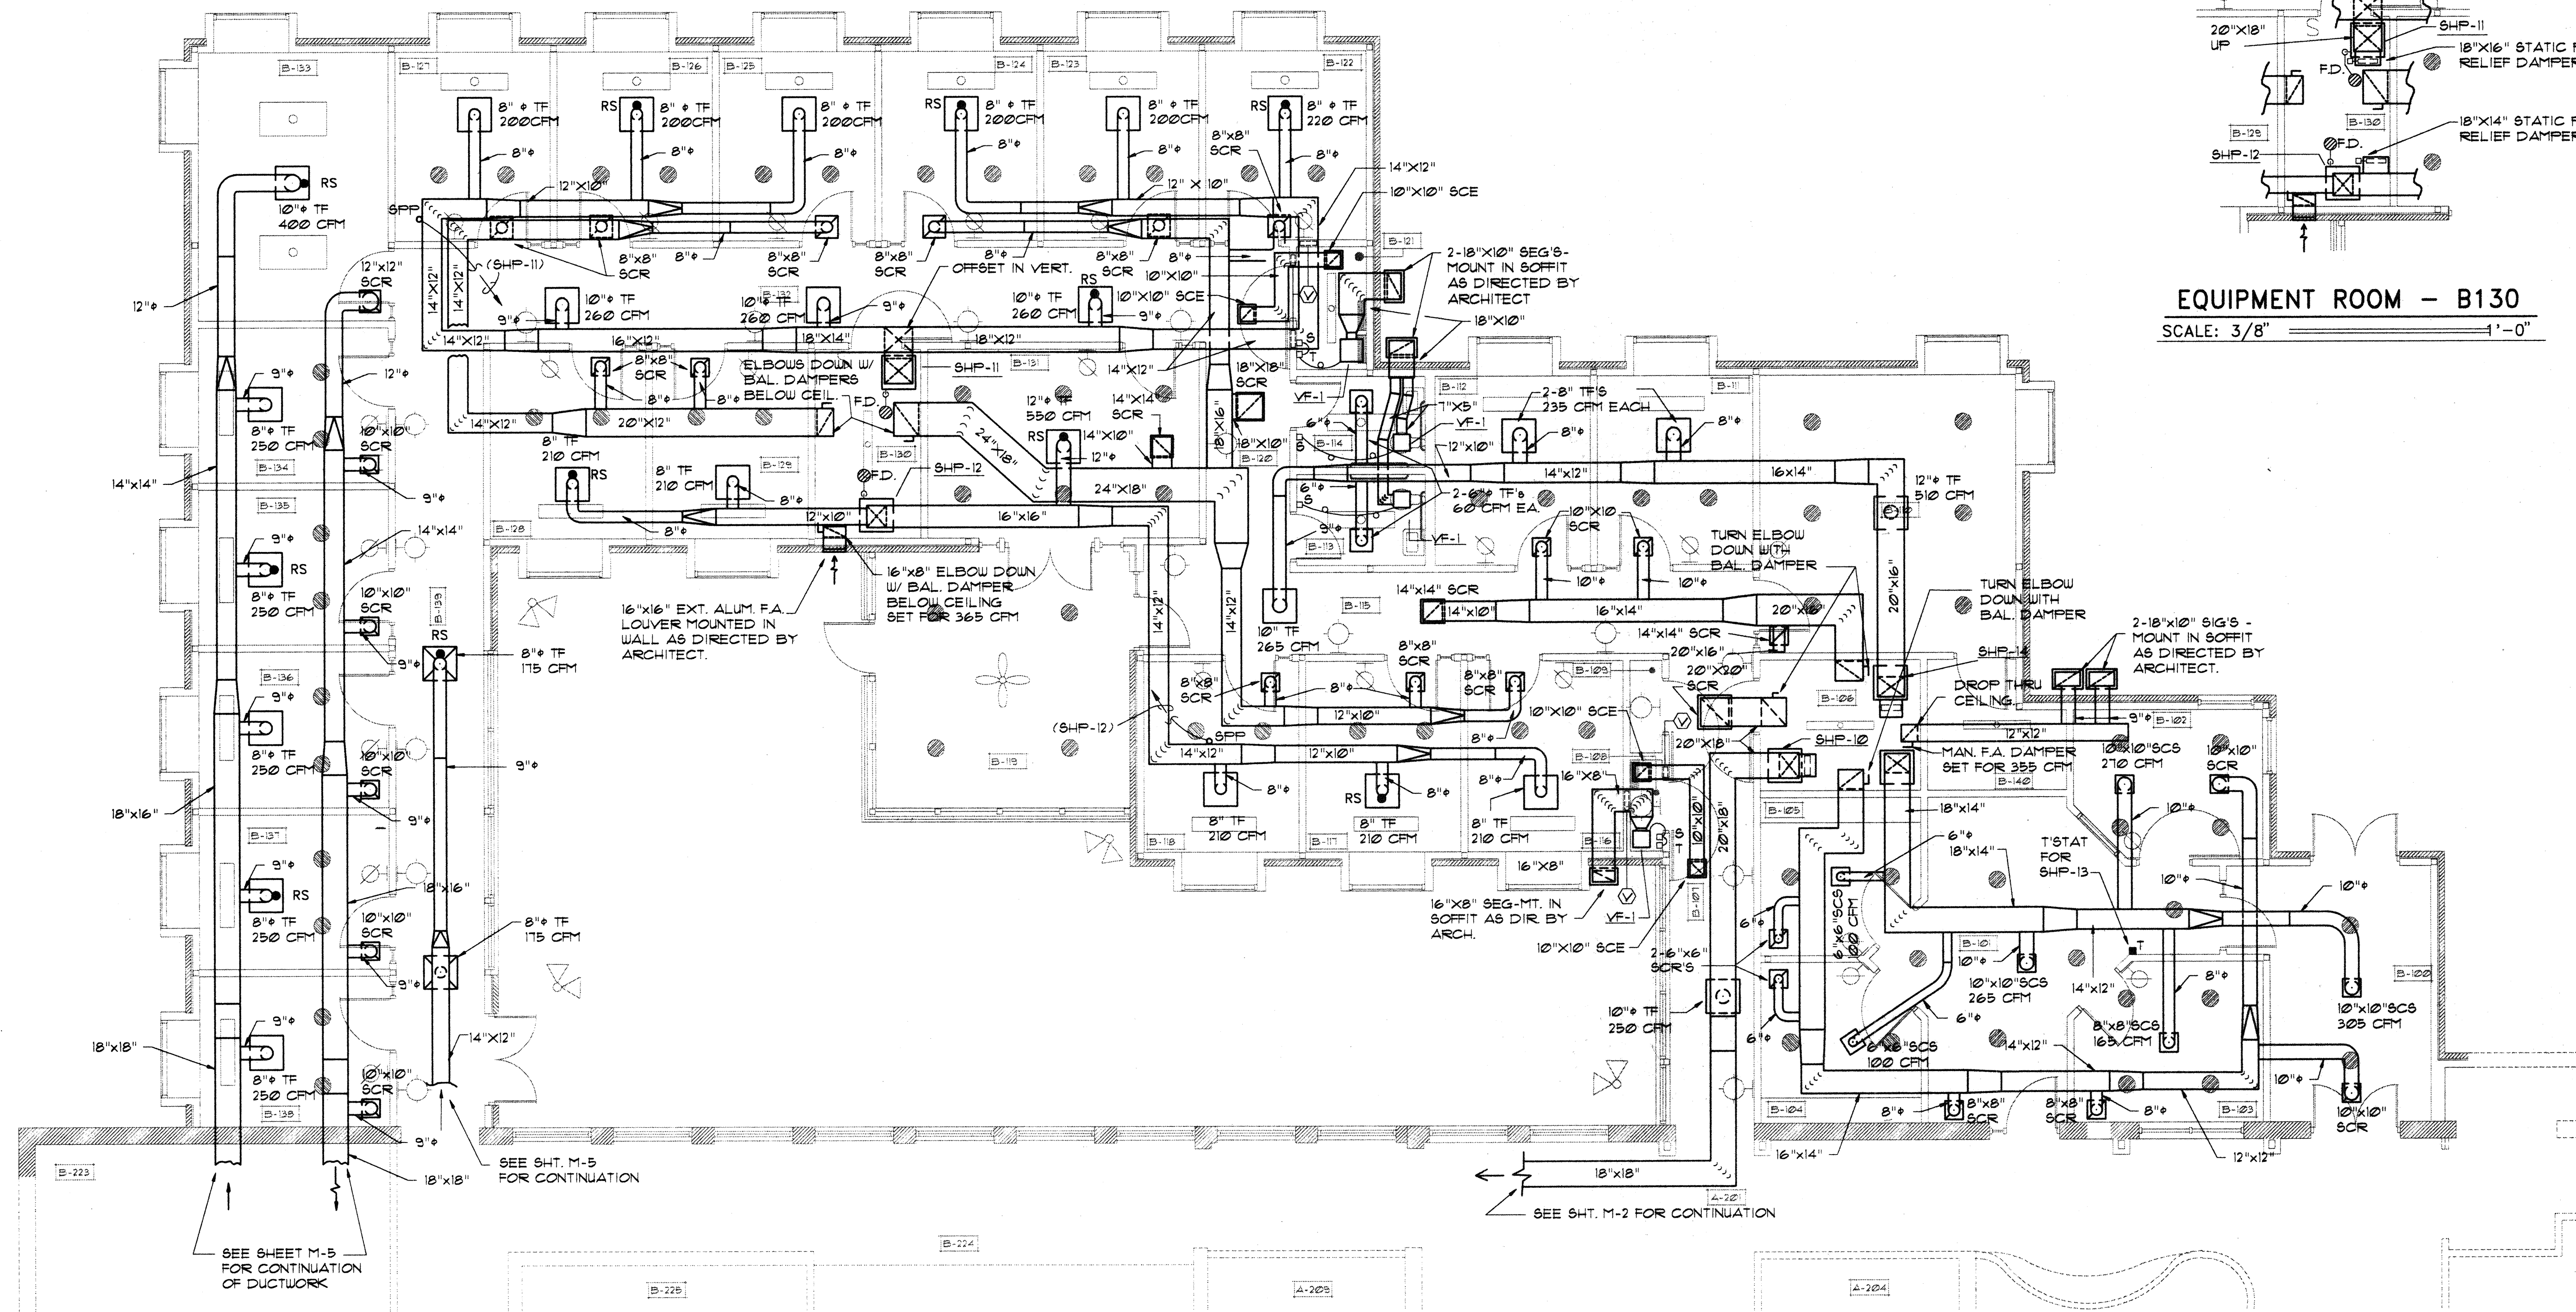

**FIRST FLOOR - B-1 WING  
HEATING AND AIR CONDITIONING PLAN**  
SCALE: 3/16" = 1'-0"

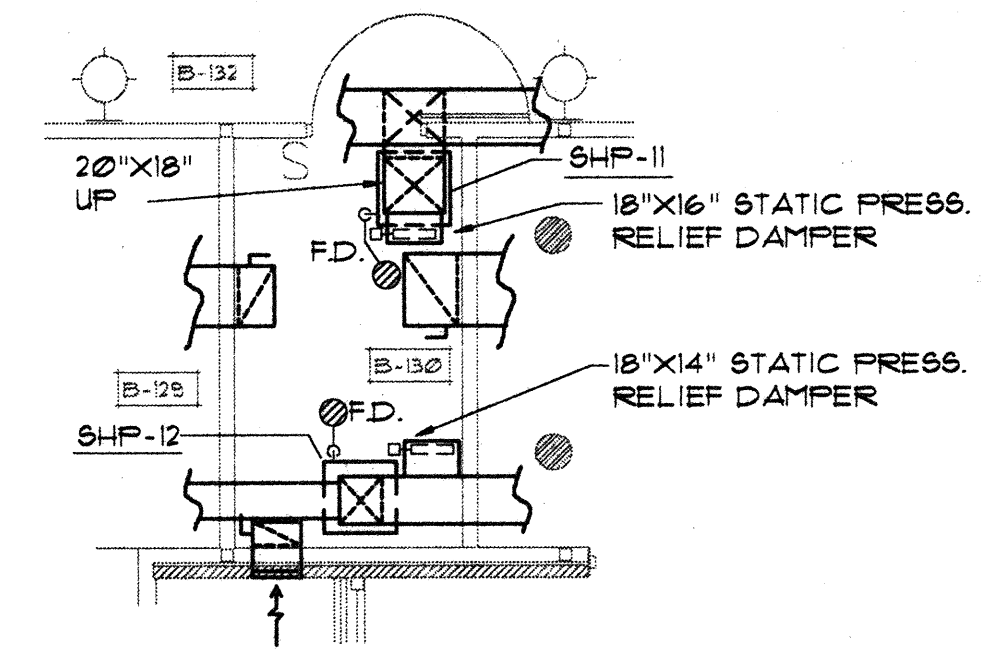

**EQUIPMENT ROOM - B130**  
SCALE: 3/8" = 1'-0"

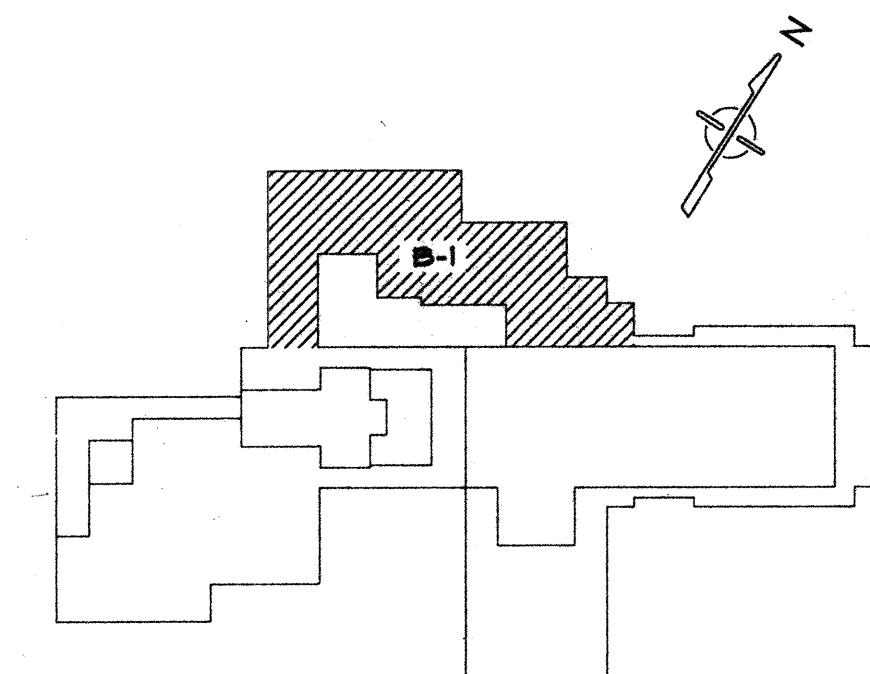

**Drakeford Architects**

120 North Main Street  
Sumter SC 29150 803 775-6567

Date April 93

Revisions

**Waccamaw  
CMHS Central  
Facility**


Horry County, S.C.

Project No. J12-9544-PM

**Heating and Air  
Conditioning**

**Floor Plan -  
B-1 Wing**

Scale: 3/16" = 1'-0"

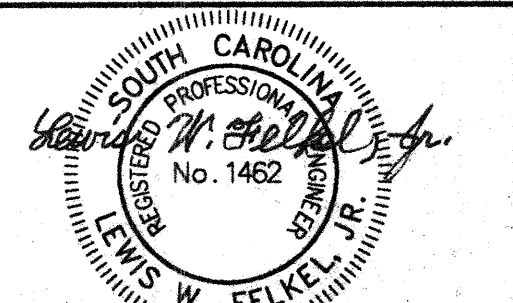

**FELKEL & HASTINGS**  
Mechanical Engineers  
2740 Devine Street  
Columbia, S.C. 29205  
Comm. No.: 1494 Date: 3-29-93

Sheet M-4 of 11



Drakeford Architects

120 North Main Street  
Sumter SC 29150 803 775-6567

Date April 93

### Revisions

Waccamaw  
CMHS Central  
Facility


Horry County, S.C.

Project No. J12-9544-PM

Heating & Air  
Conditioning


Floor Plan -  
B-2 Wing

Scale:  $3/16" = 1'0"$

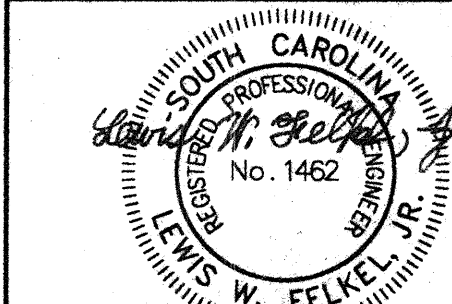


FELKEL & HASTINGS  
Mechanical Engineers  
2740 Devine Street  
Columbia, S.C. 29205  
Comm. No.: 1494 Date: 3-29-9


Sheet M-5 of 11

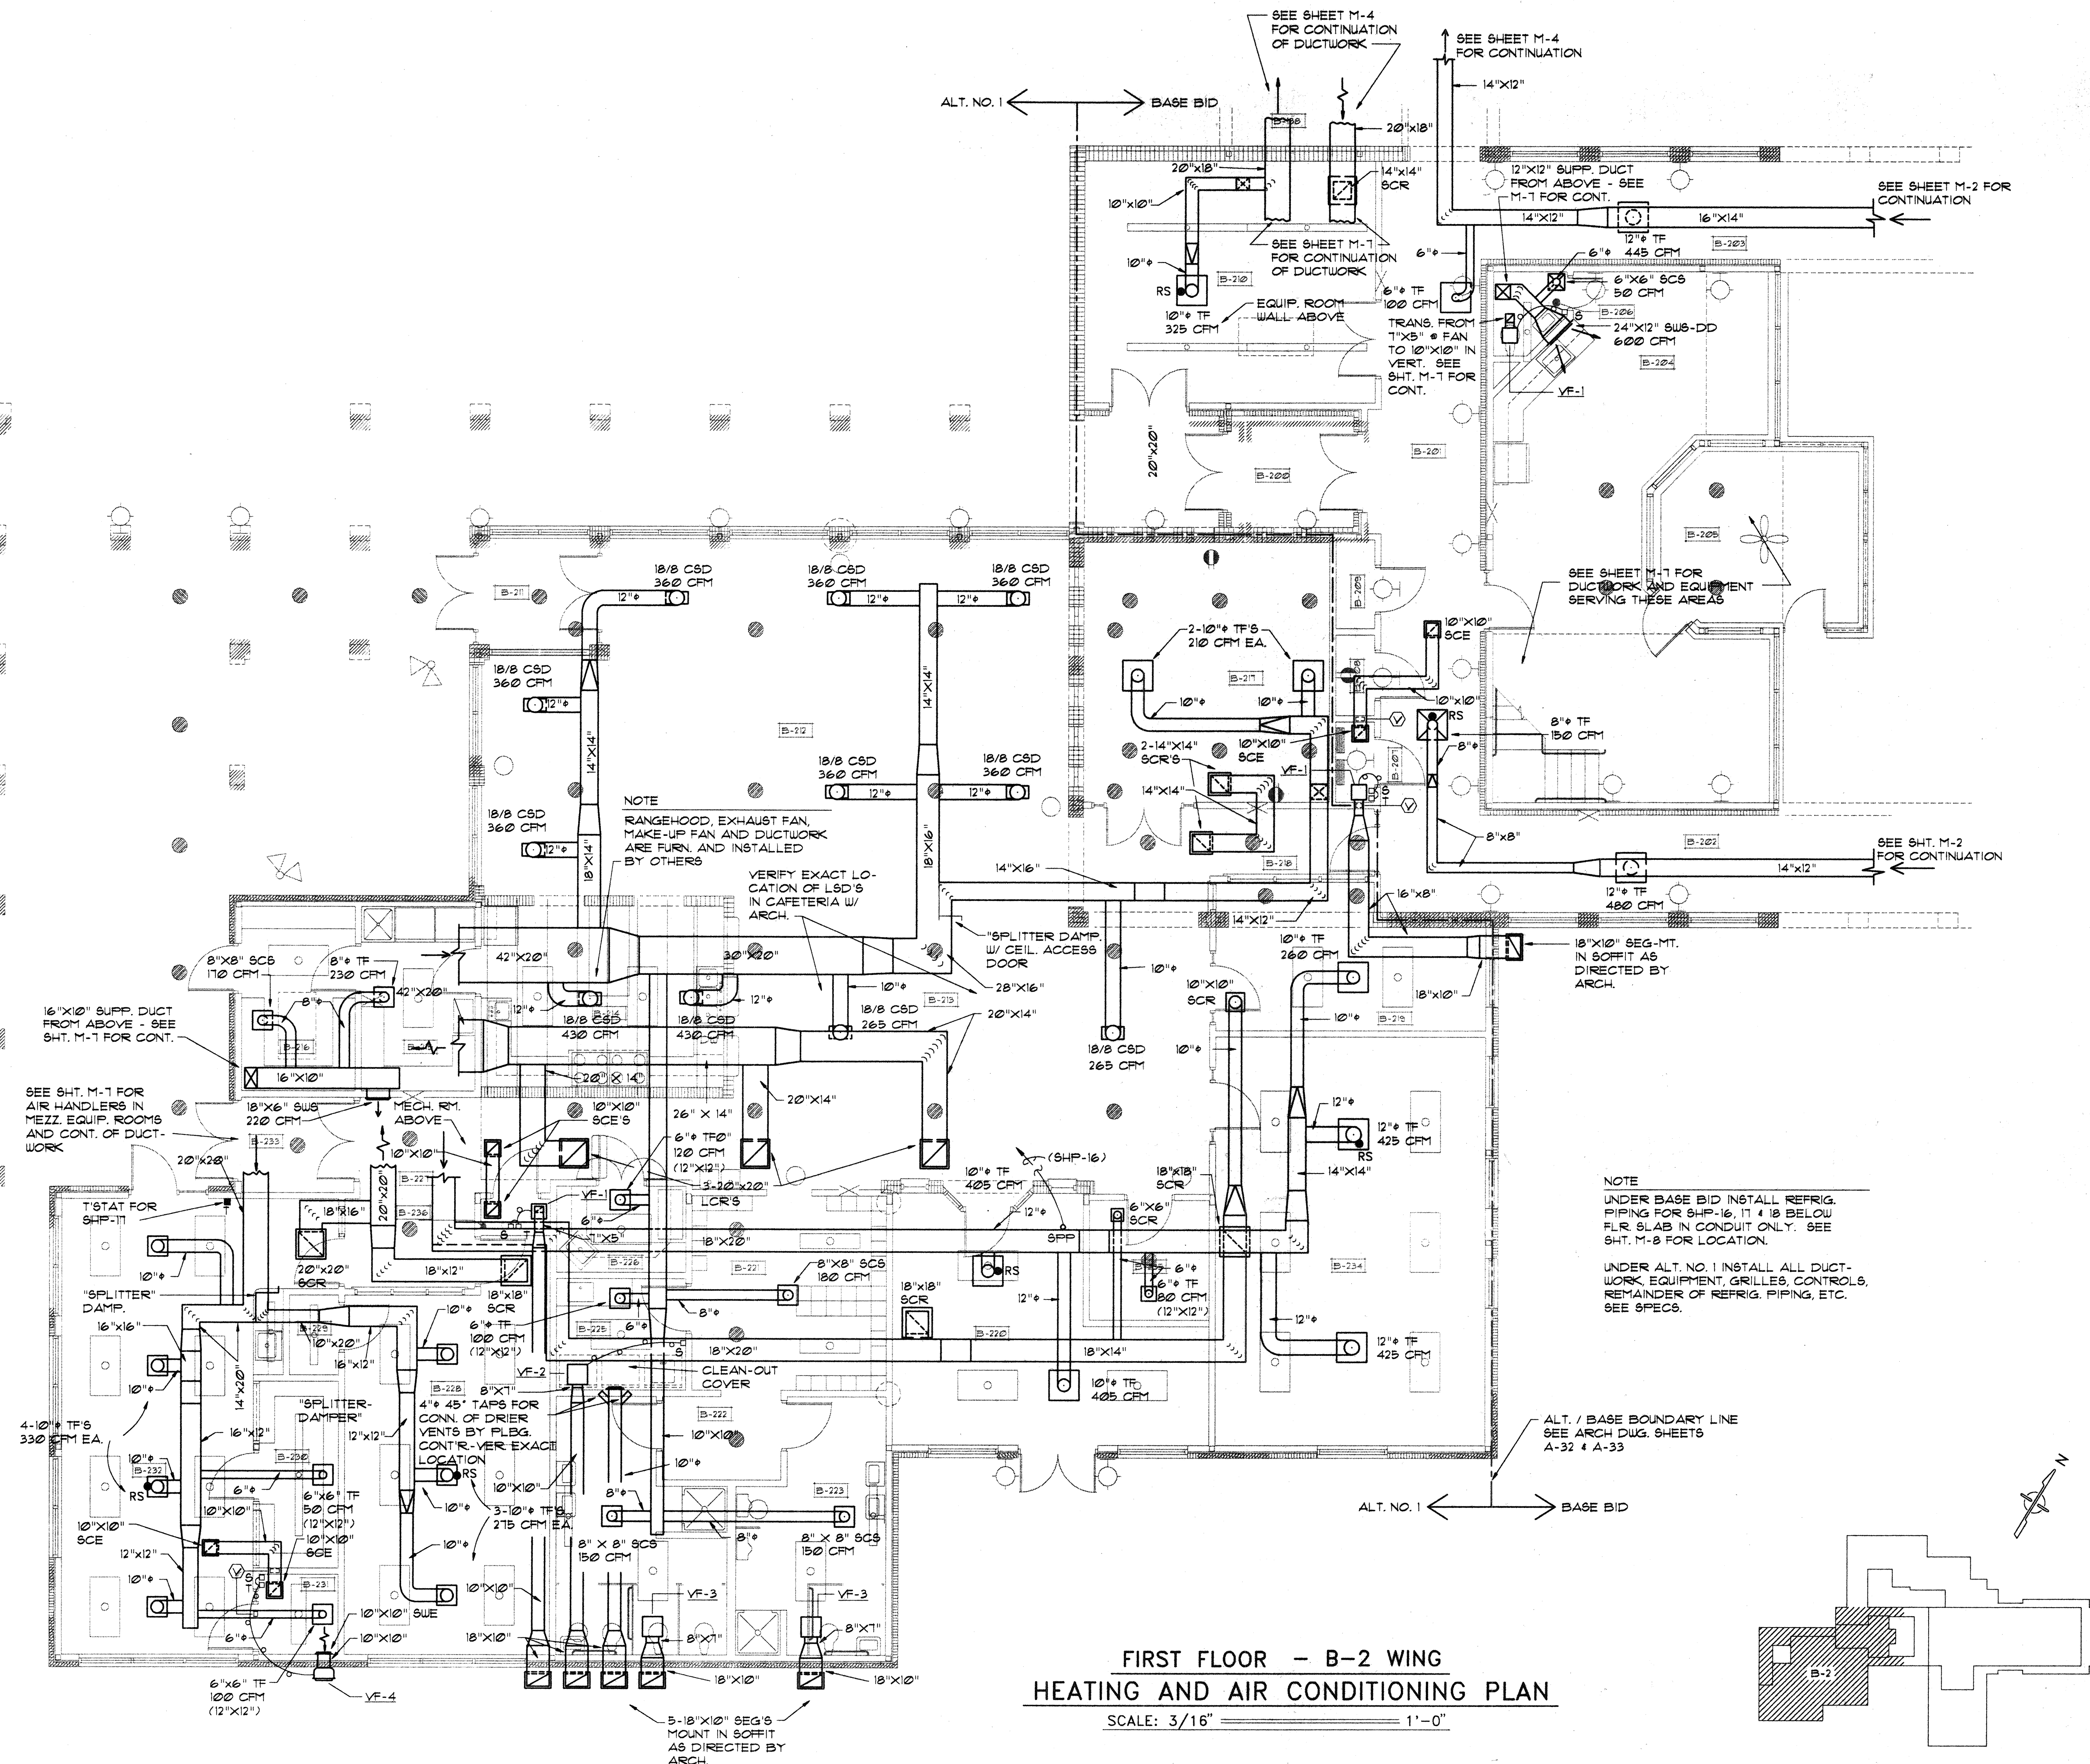



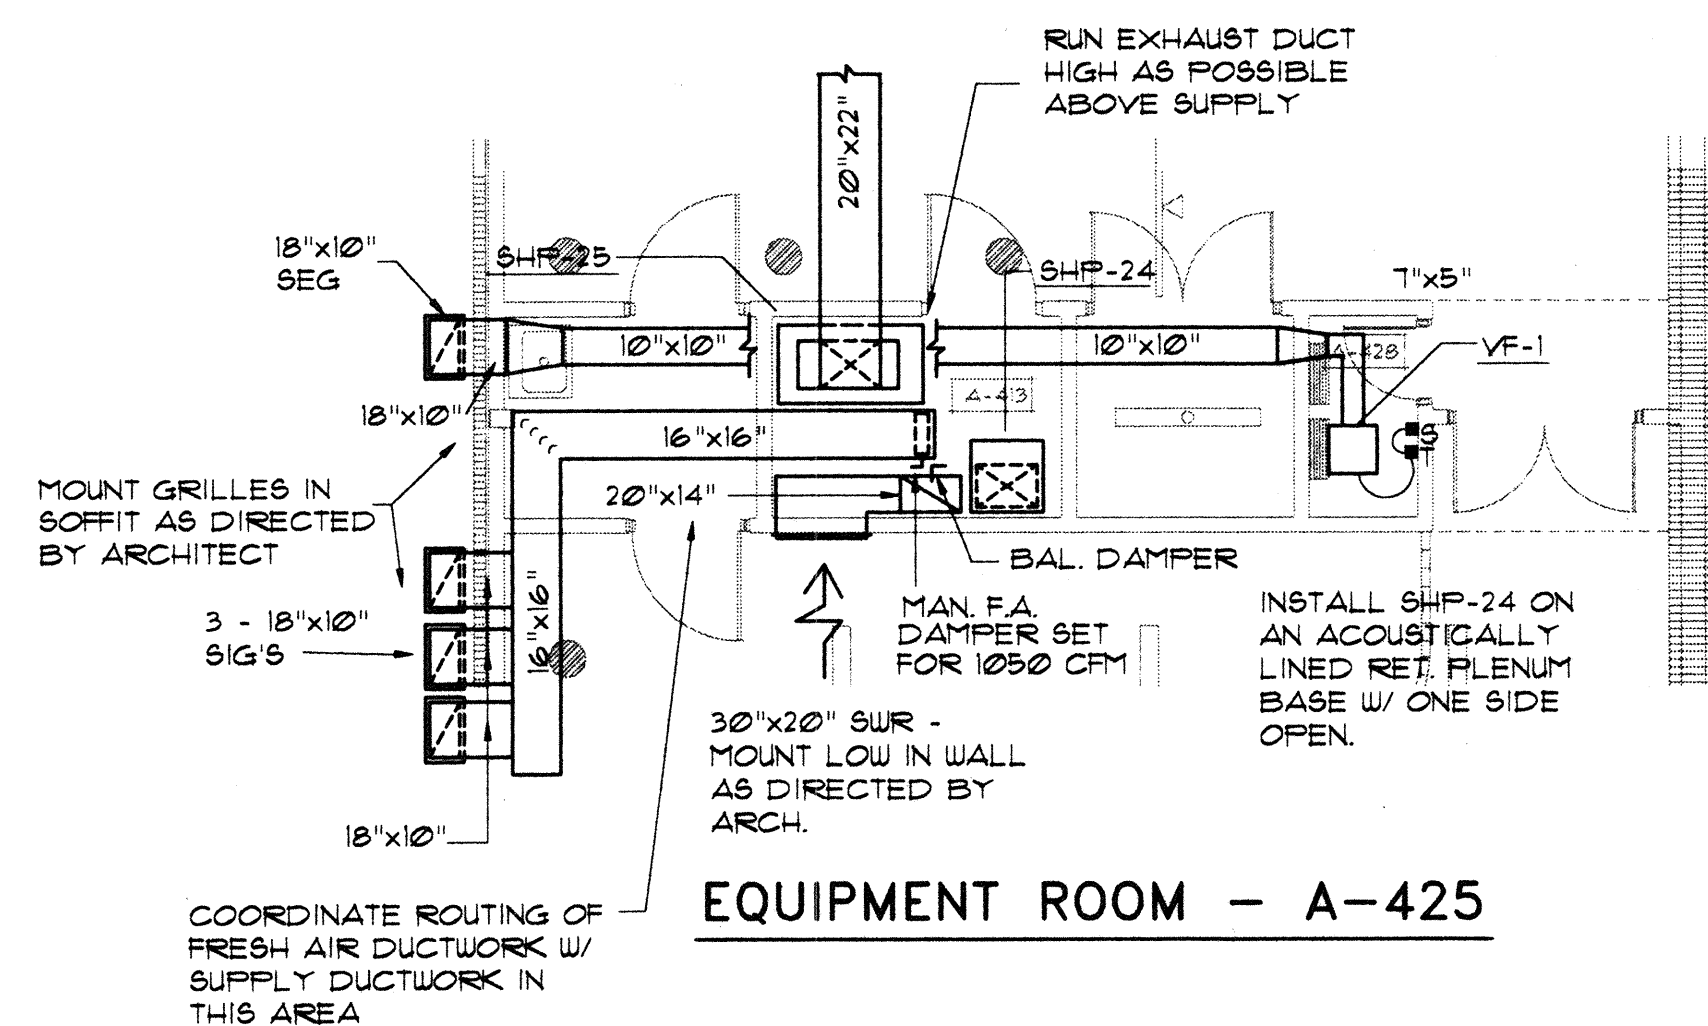


EQUIPMENT ROOM - A-425

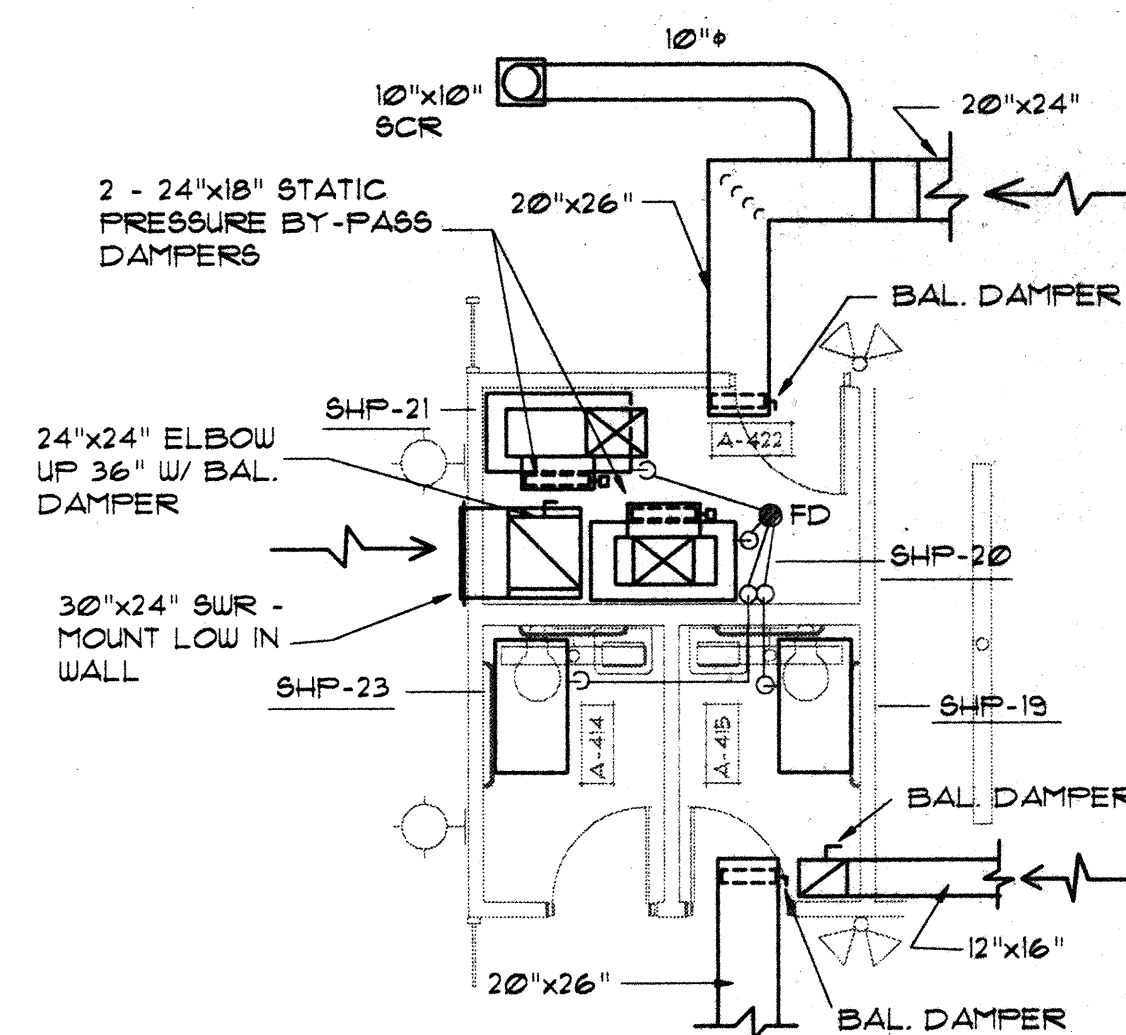


EQUIPMENT ROOM - A-422

NOTES

1. SHP-19 AND SHP-23 ARE LOCATED ON MEZZ. FLOOR ABOVE TOILET CEILING.
2. INSTALL AUX. DRAIN PANS W/ FLOAT SWITCHES UNDER THESE TWO UNITS.
3. COORDINATE ROUTING OF DUCTWORK AROUND THESE UNITS SO AS TO PROVIDE ADEQUATE ACCESS FOR SERVICE.

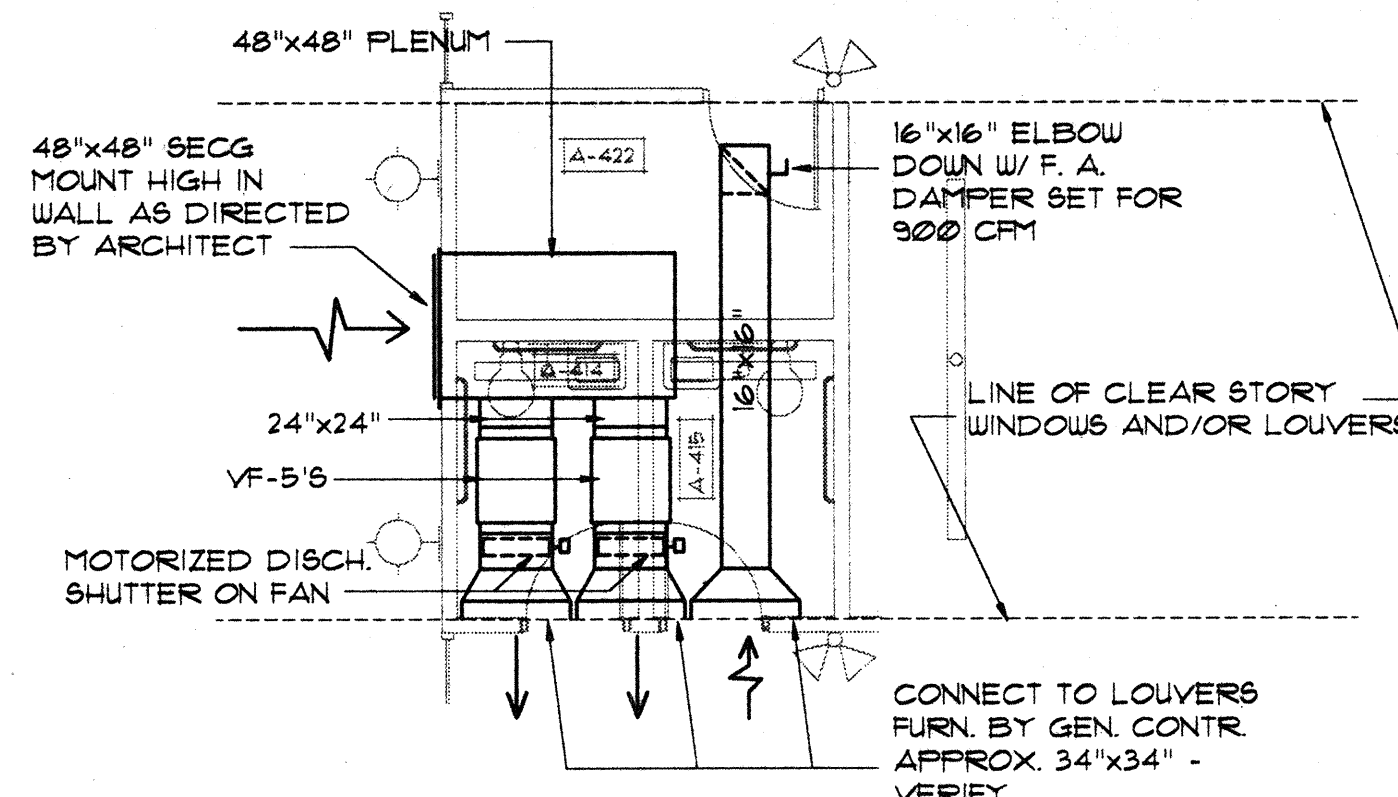


UPPER EQUIP. RM. - A-422

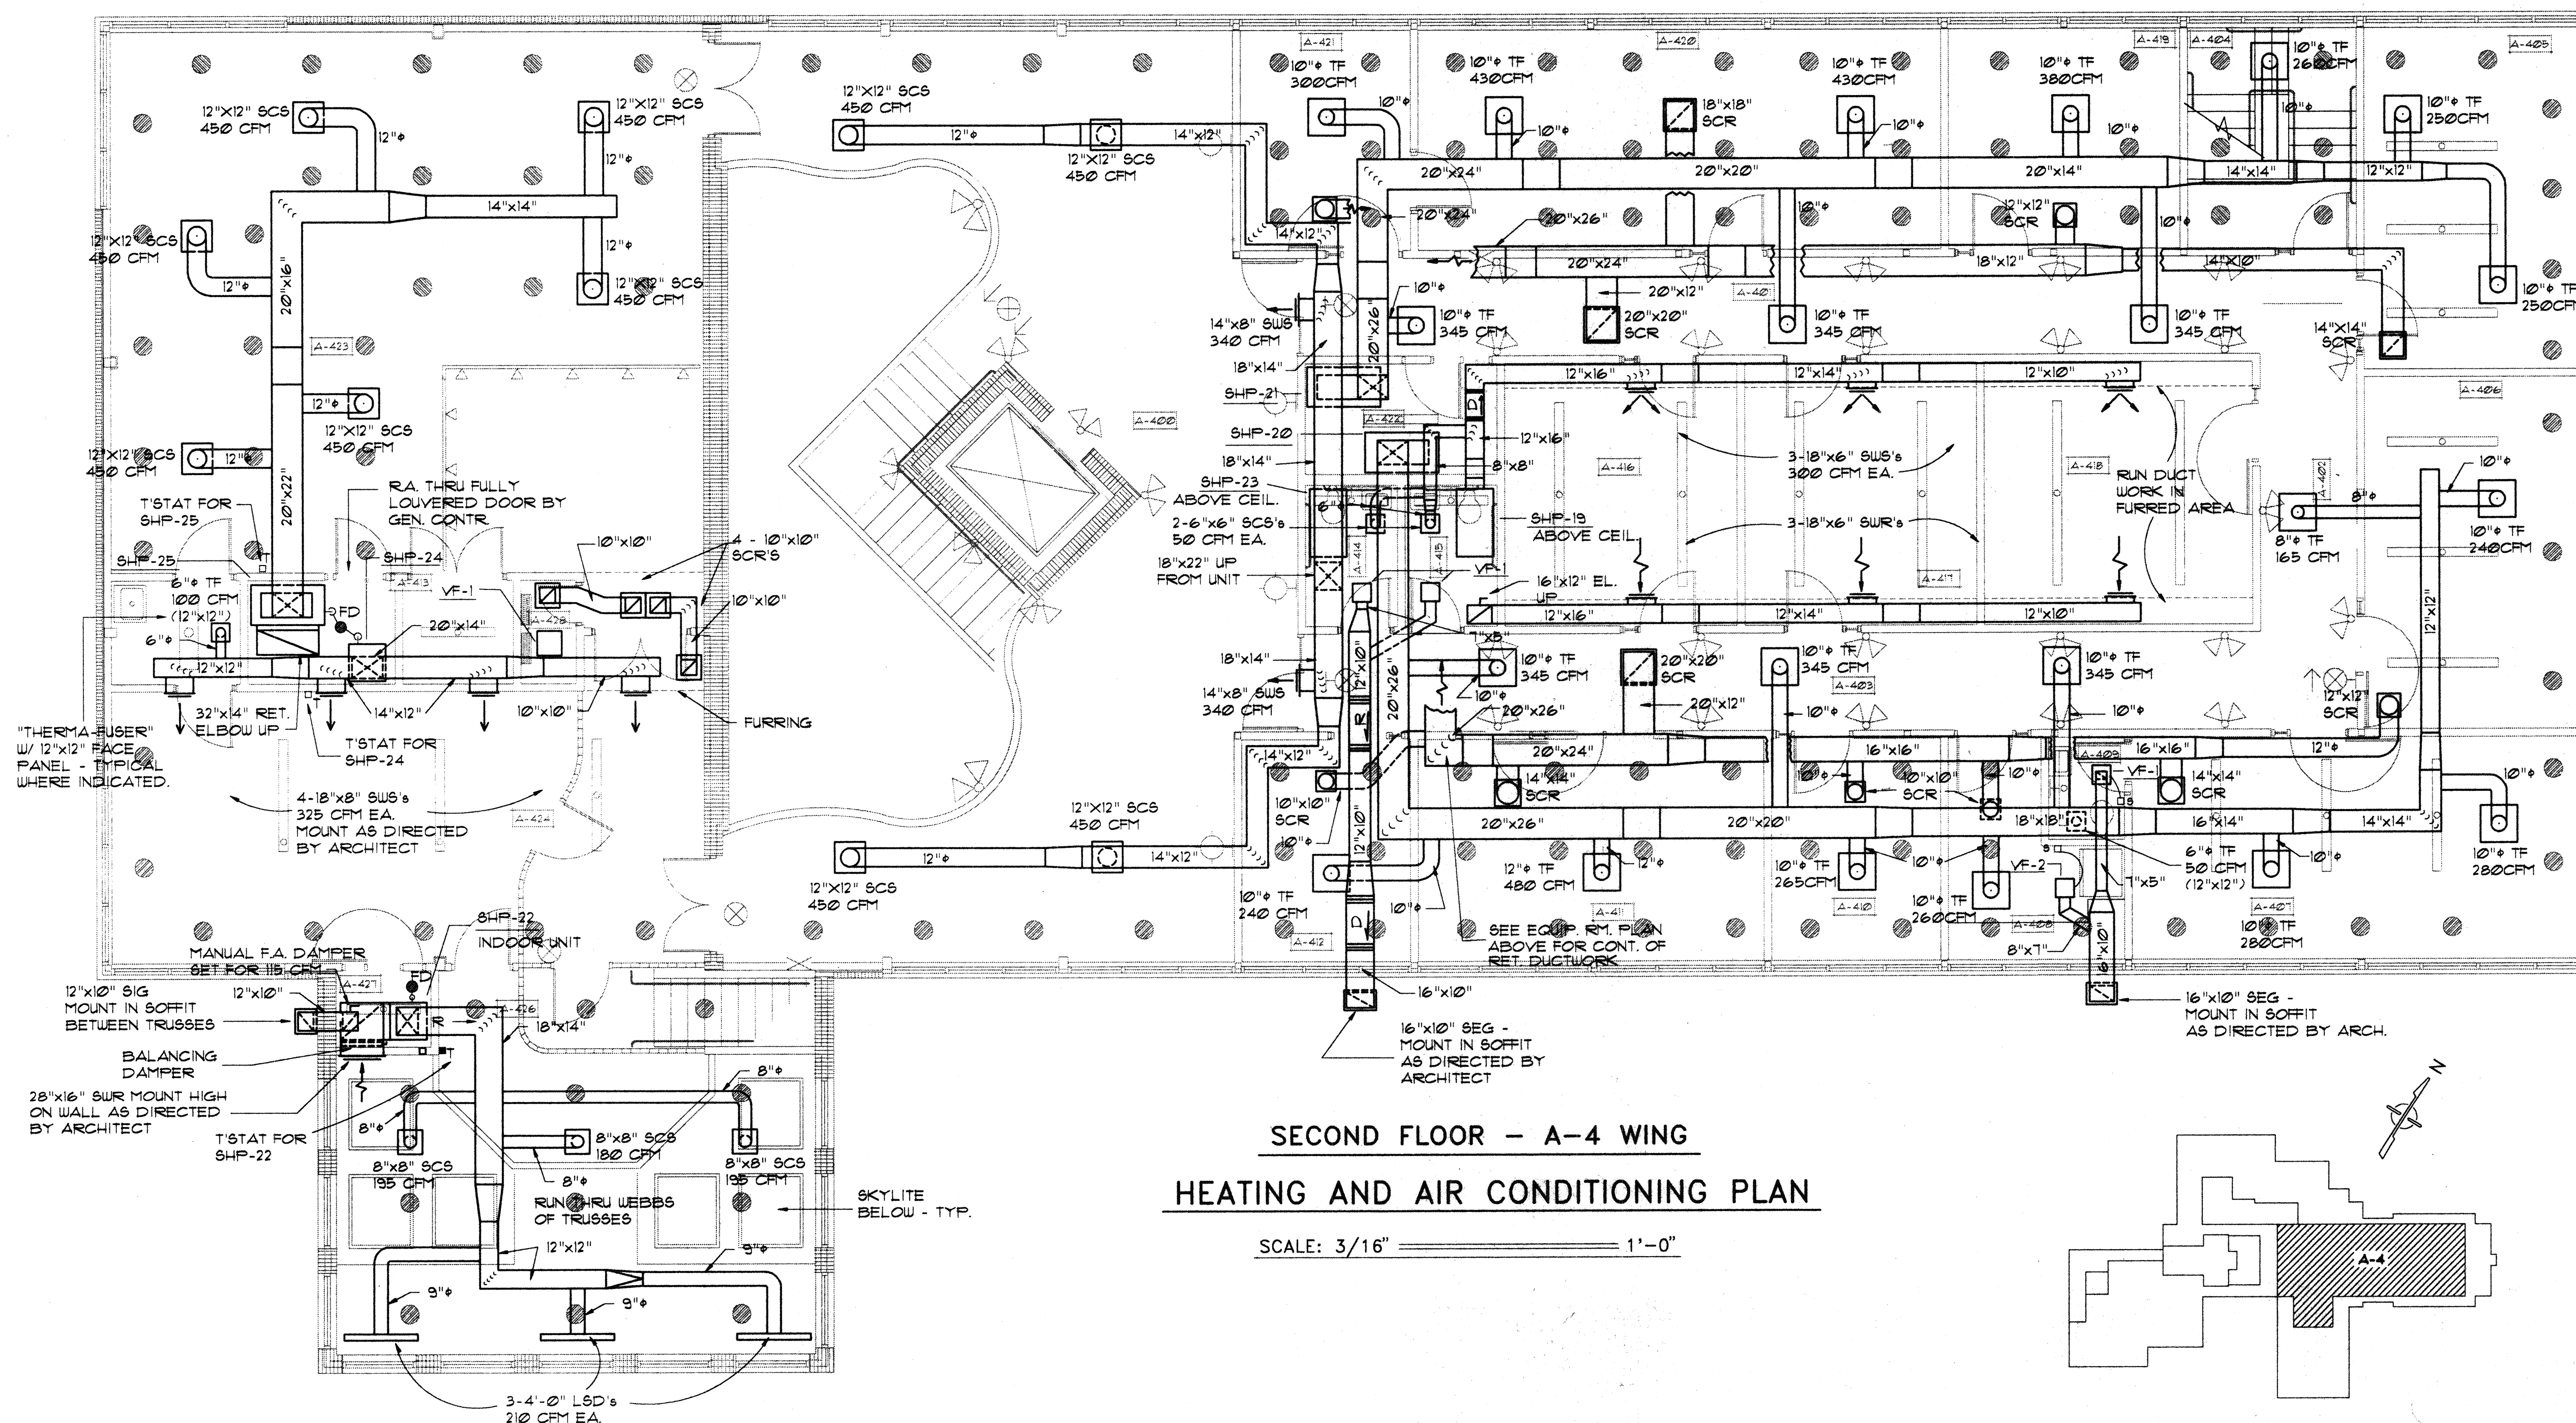

SECOND FLOOR - A-4 WING  
HEATING AND AIR CONDITIONING PLAN

SCALE: 3/16" = 1'-0"

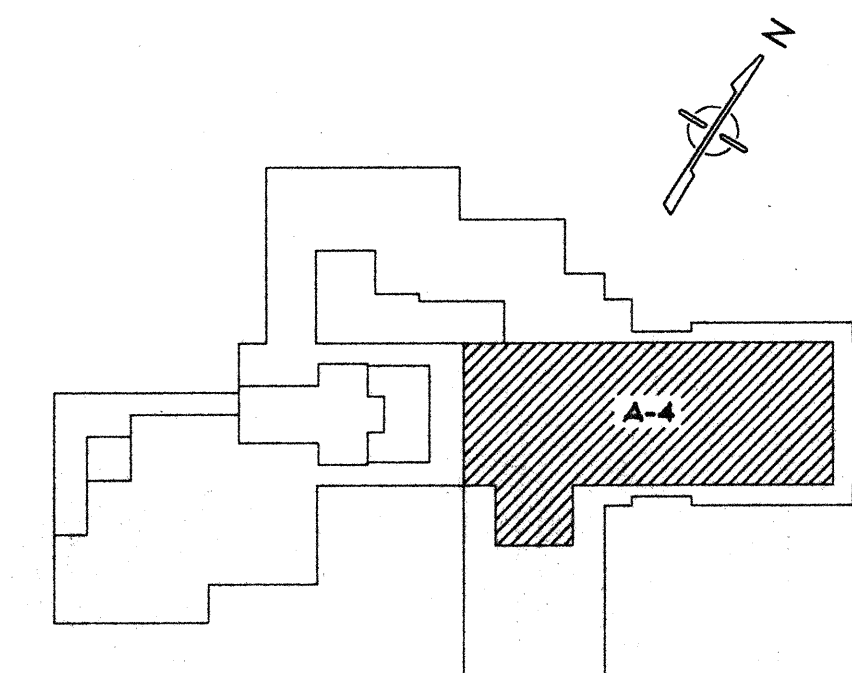

Drakeford Architects

120 North Main Street  
Sumter SC 29150 803 775-8507

Date April 93

Revisions


Waccamaw  
CMHS Central  
Facility

Horry County, S.C.

Project No. J12-9544-PM

Heating & Air  
Conditioning  
Floor Plan -  
A-4 Wing







Scale: 3/16" = 1'-0"

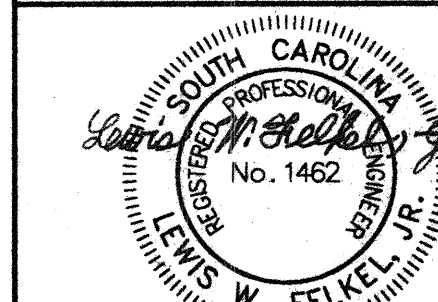


FELKEL & HASTINGS  
Mechanical Engineers  
2740 Devine Street  
Columbia, S.C. 29205  
Comm. No.: 1494 Date: 3-29-93

Sheet M-6 of 11



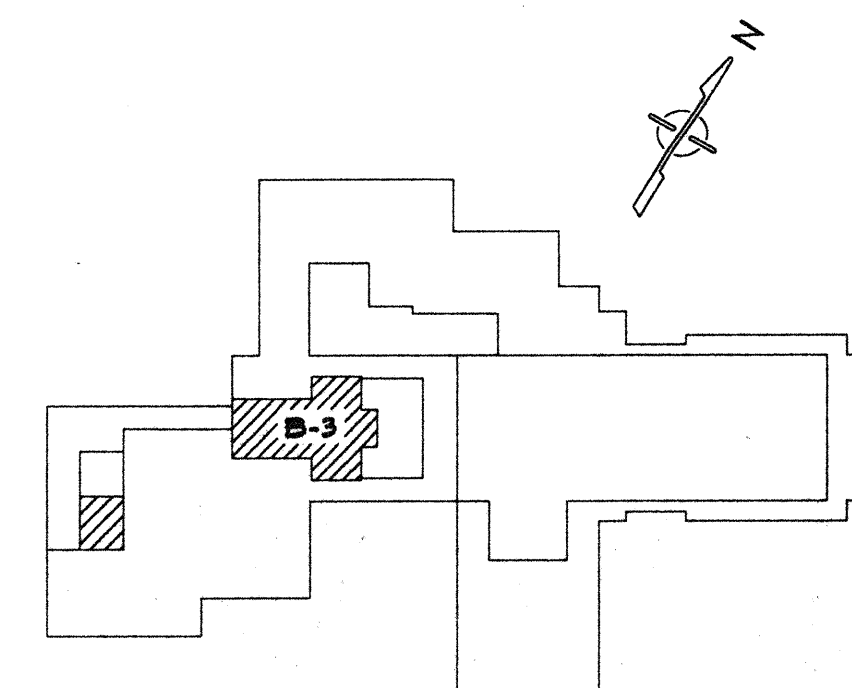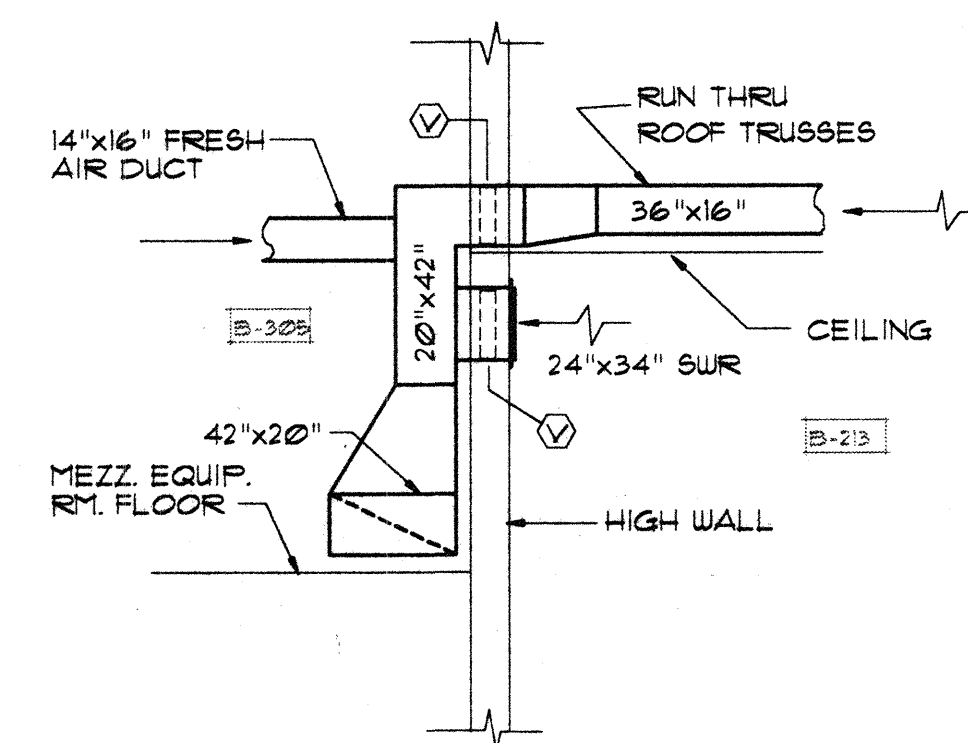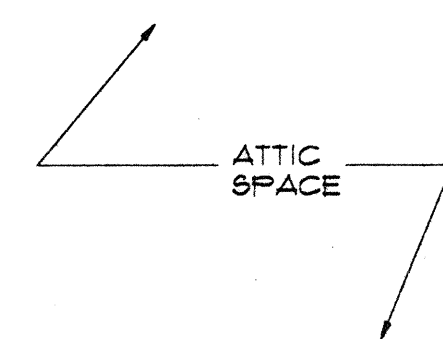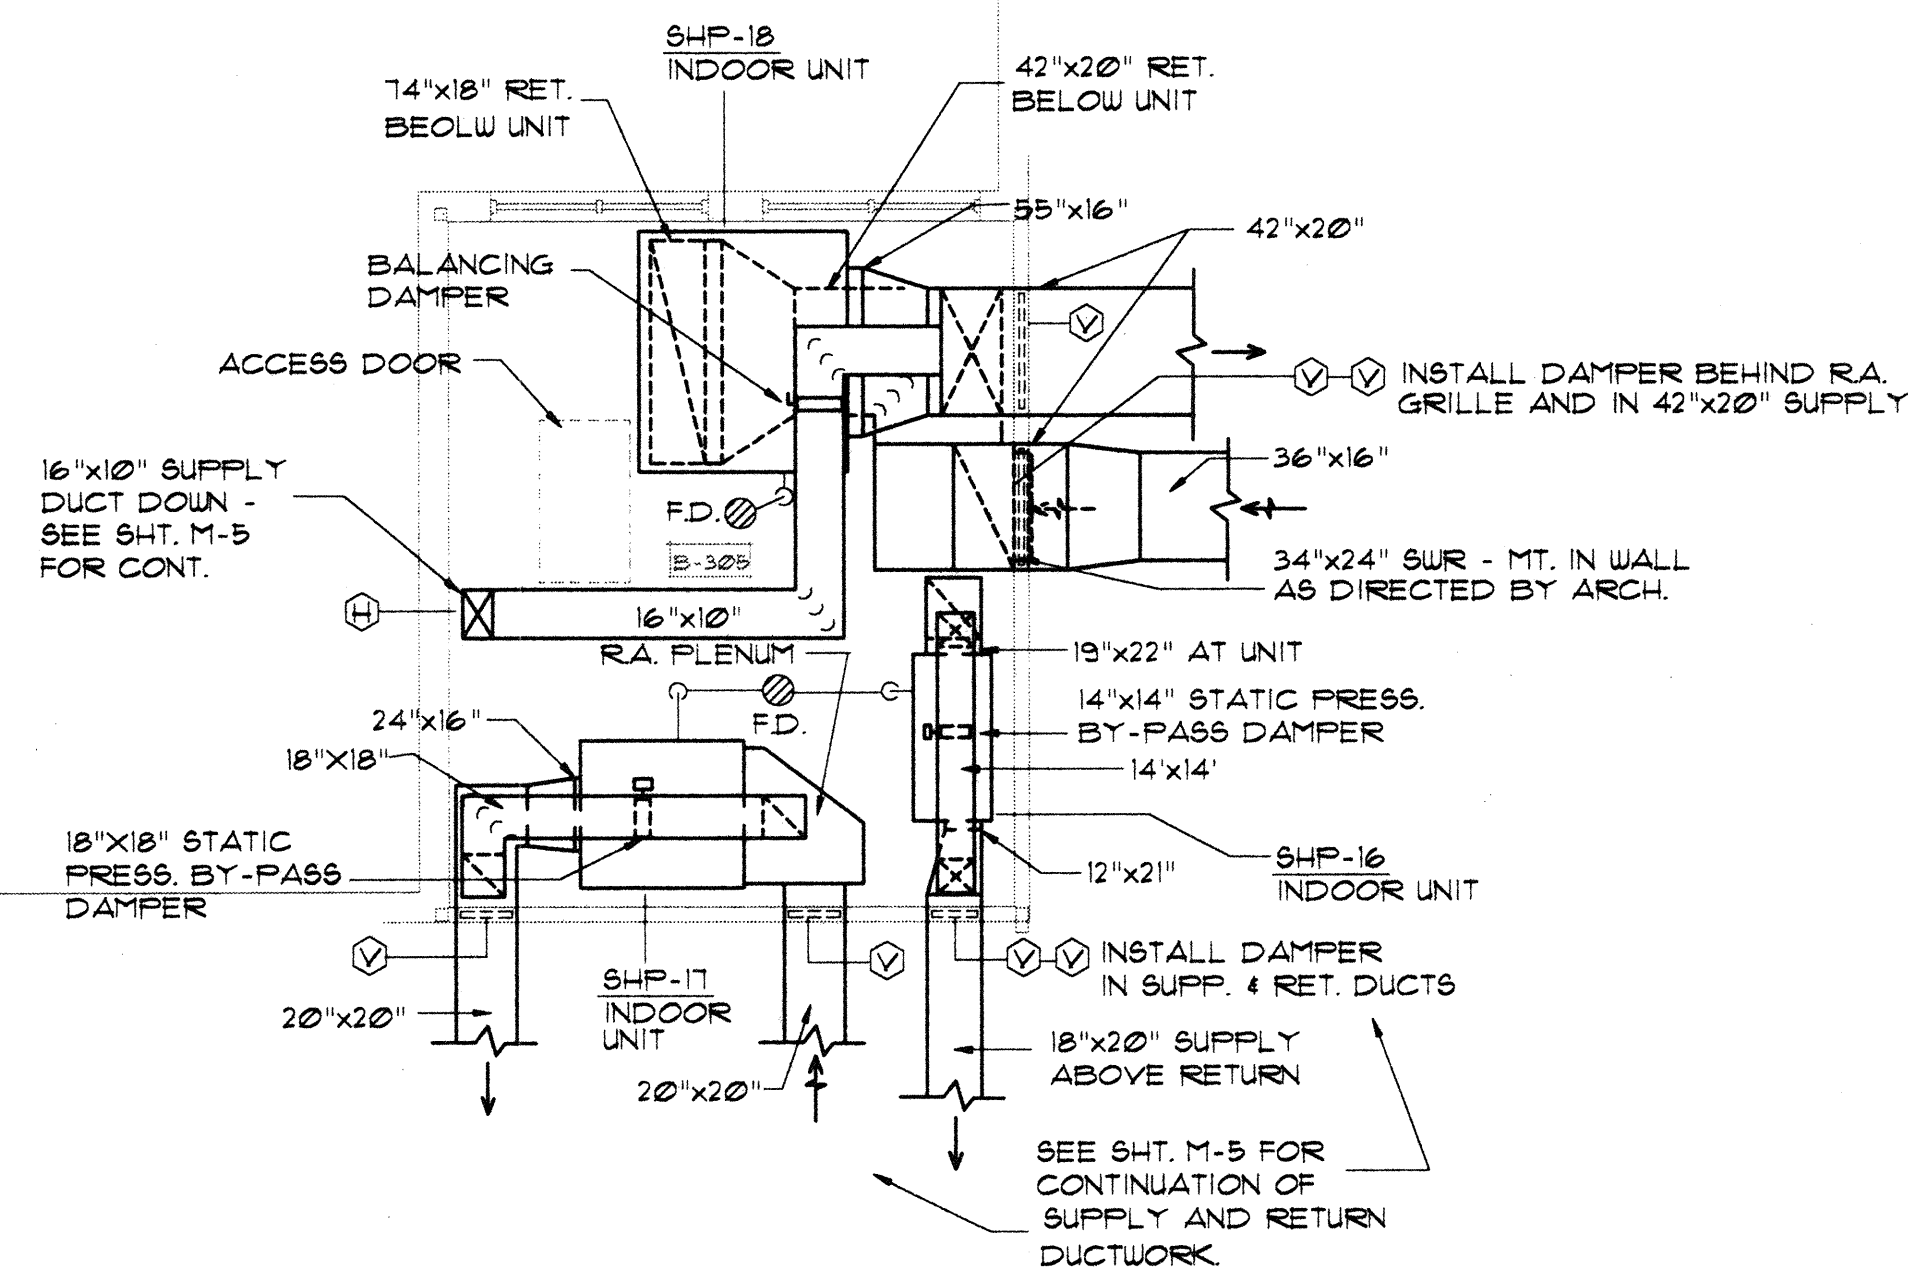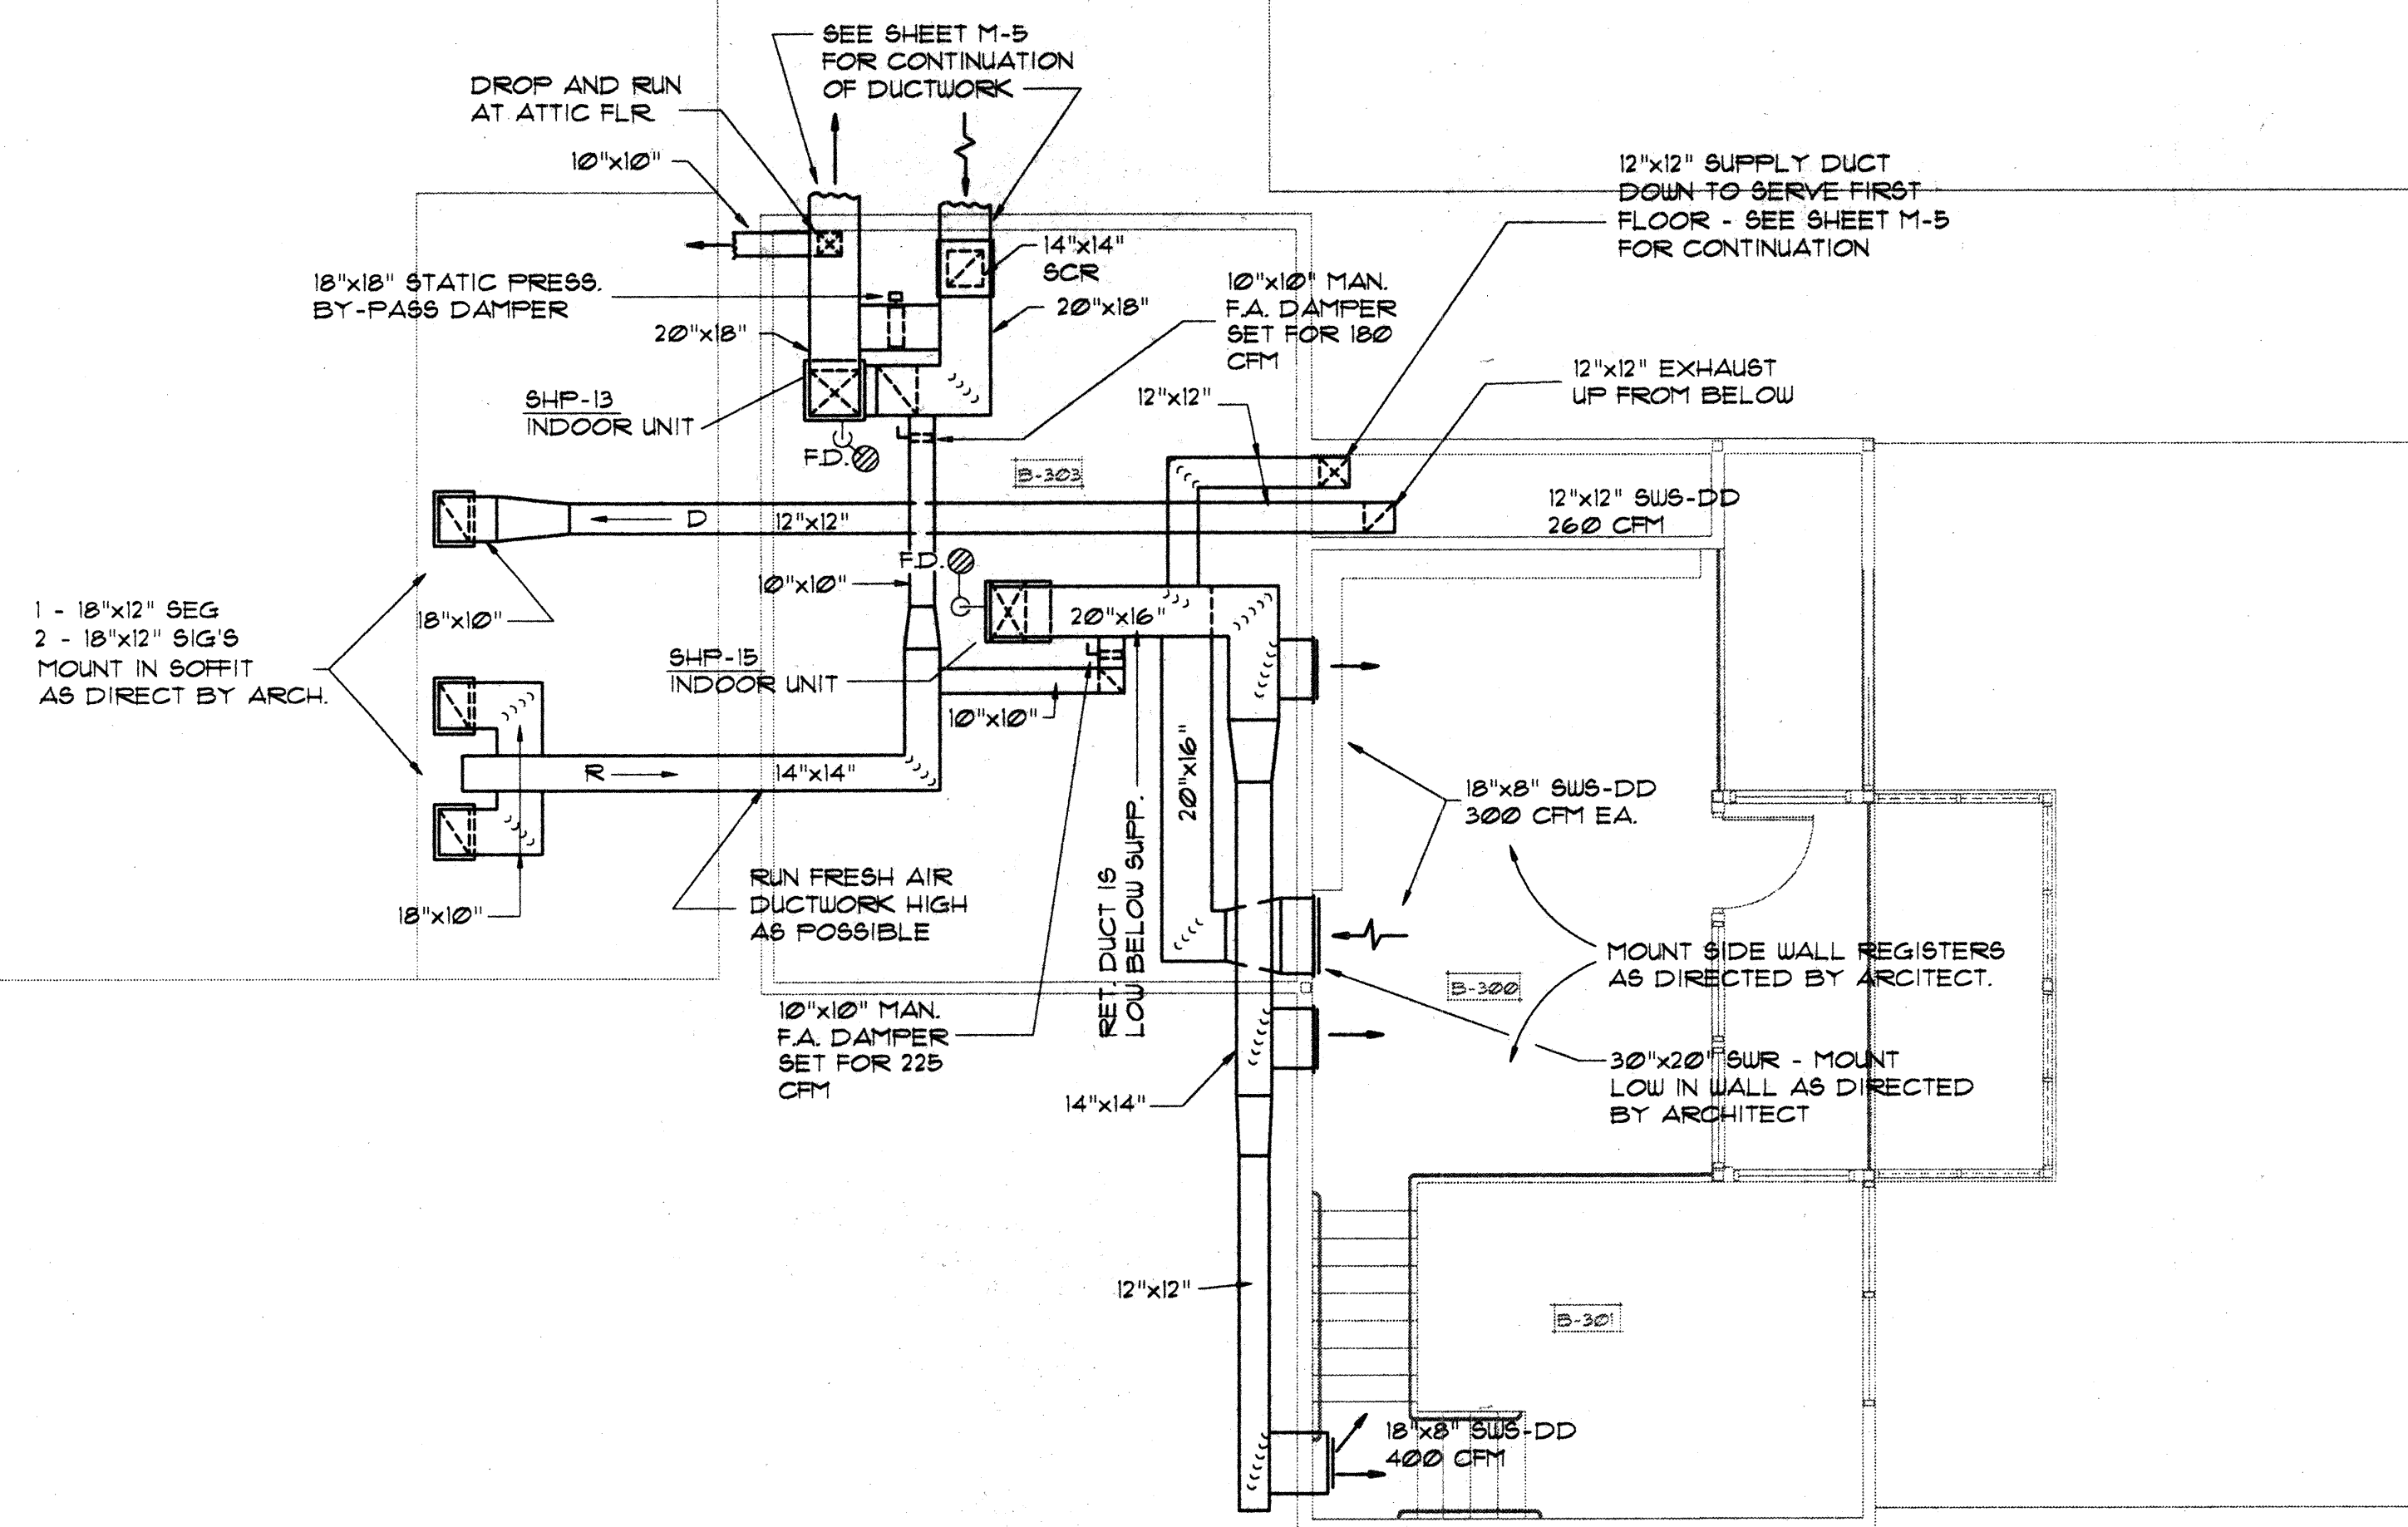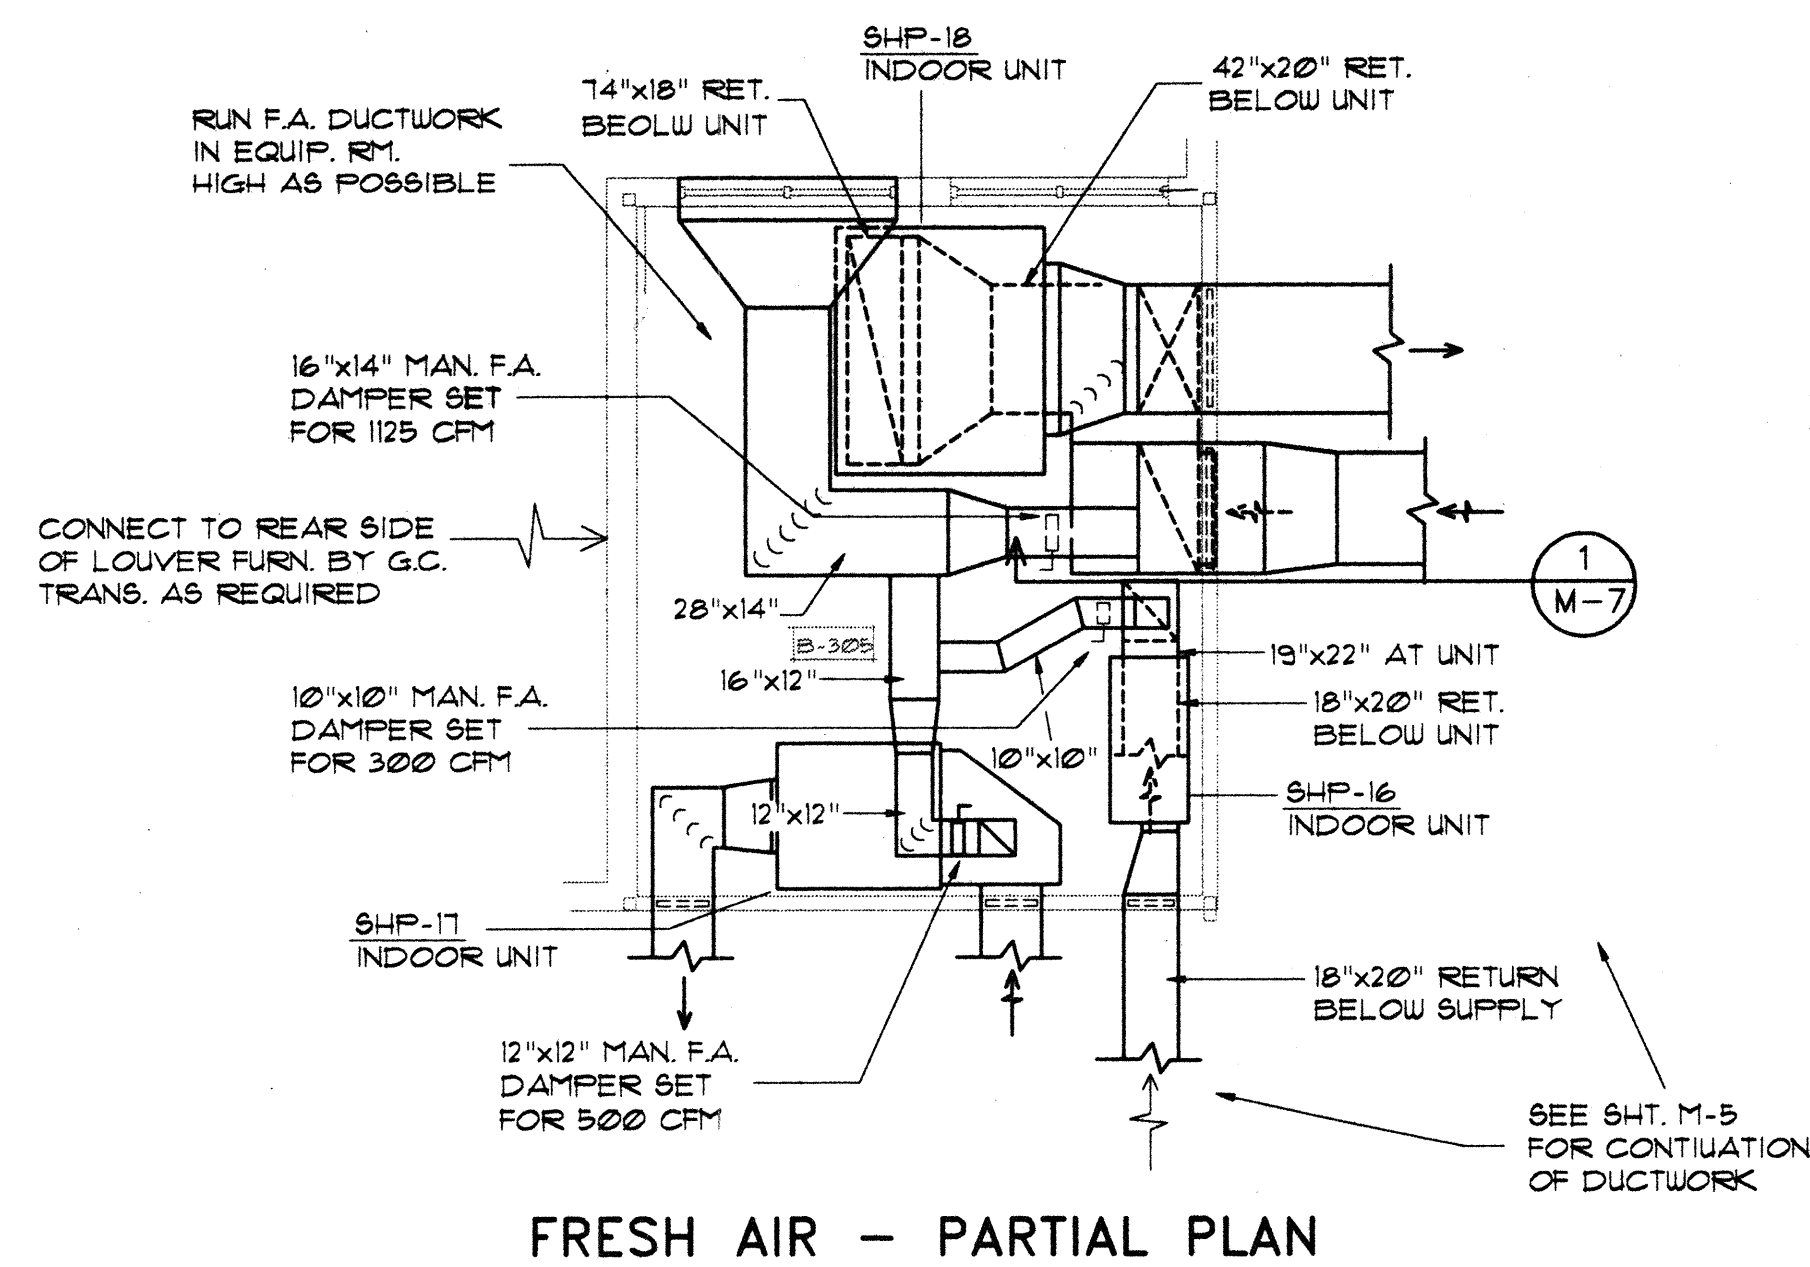

SECOND FLOOR - B-3 WING  
HEATING AND AIR CONDITIONING PLAN

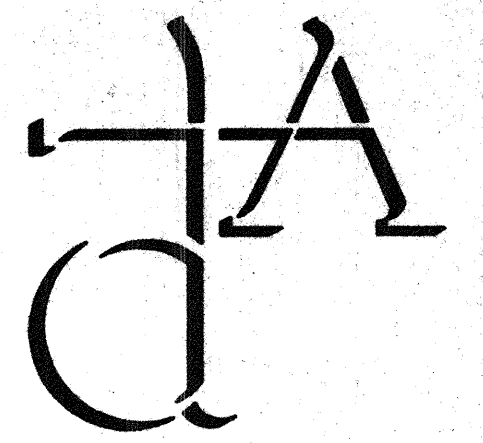

120 North Main Street  
Sumter SC 29150 803 775-6567

Date April 93

## Revisions

Waccamaw  
CMHS Central  
Facility


Horry County, S.C.

Project No. J12-9544-PM

Floor Plan -  
B-3 Wing

Heating and Air Conditioning

Scale:  $3/16" = 1'0"$

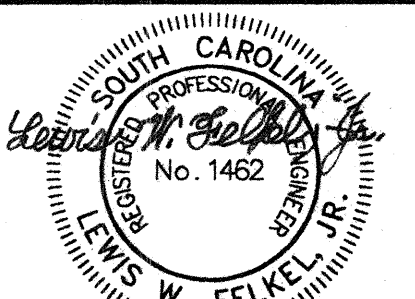

**FELKEL & HASTINGS**  
Mechanical Engineers  
2740 Devine Street  
Columbia, S.C. 29205  
Comm. No.: 1494 Date: 3-29-93

Sheet M-7 of 11





Drakeford Architects

120 North Main Street  
Sumter SC 29150 803 775-8587

Date April 93

Revisions

Waccamaw  
CMHS Central  
Facility

Horry County, S.C.


Project No. J12-9544-PM

Heating and Air  
Conditioning

Unit Locations -  
Zoning


First Floor Plan

Scale: 3/32" = 1'-0"

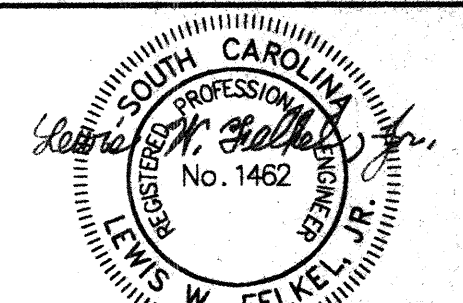

FELKEL & HASTINGS  
Mechanical Engineers  
2740 Devine Street  
Columbia, S.C. 29205  
Comm. No.: 1494 Date: 3-29-93


Sheet M-8 of 11

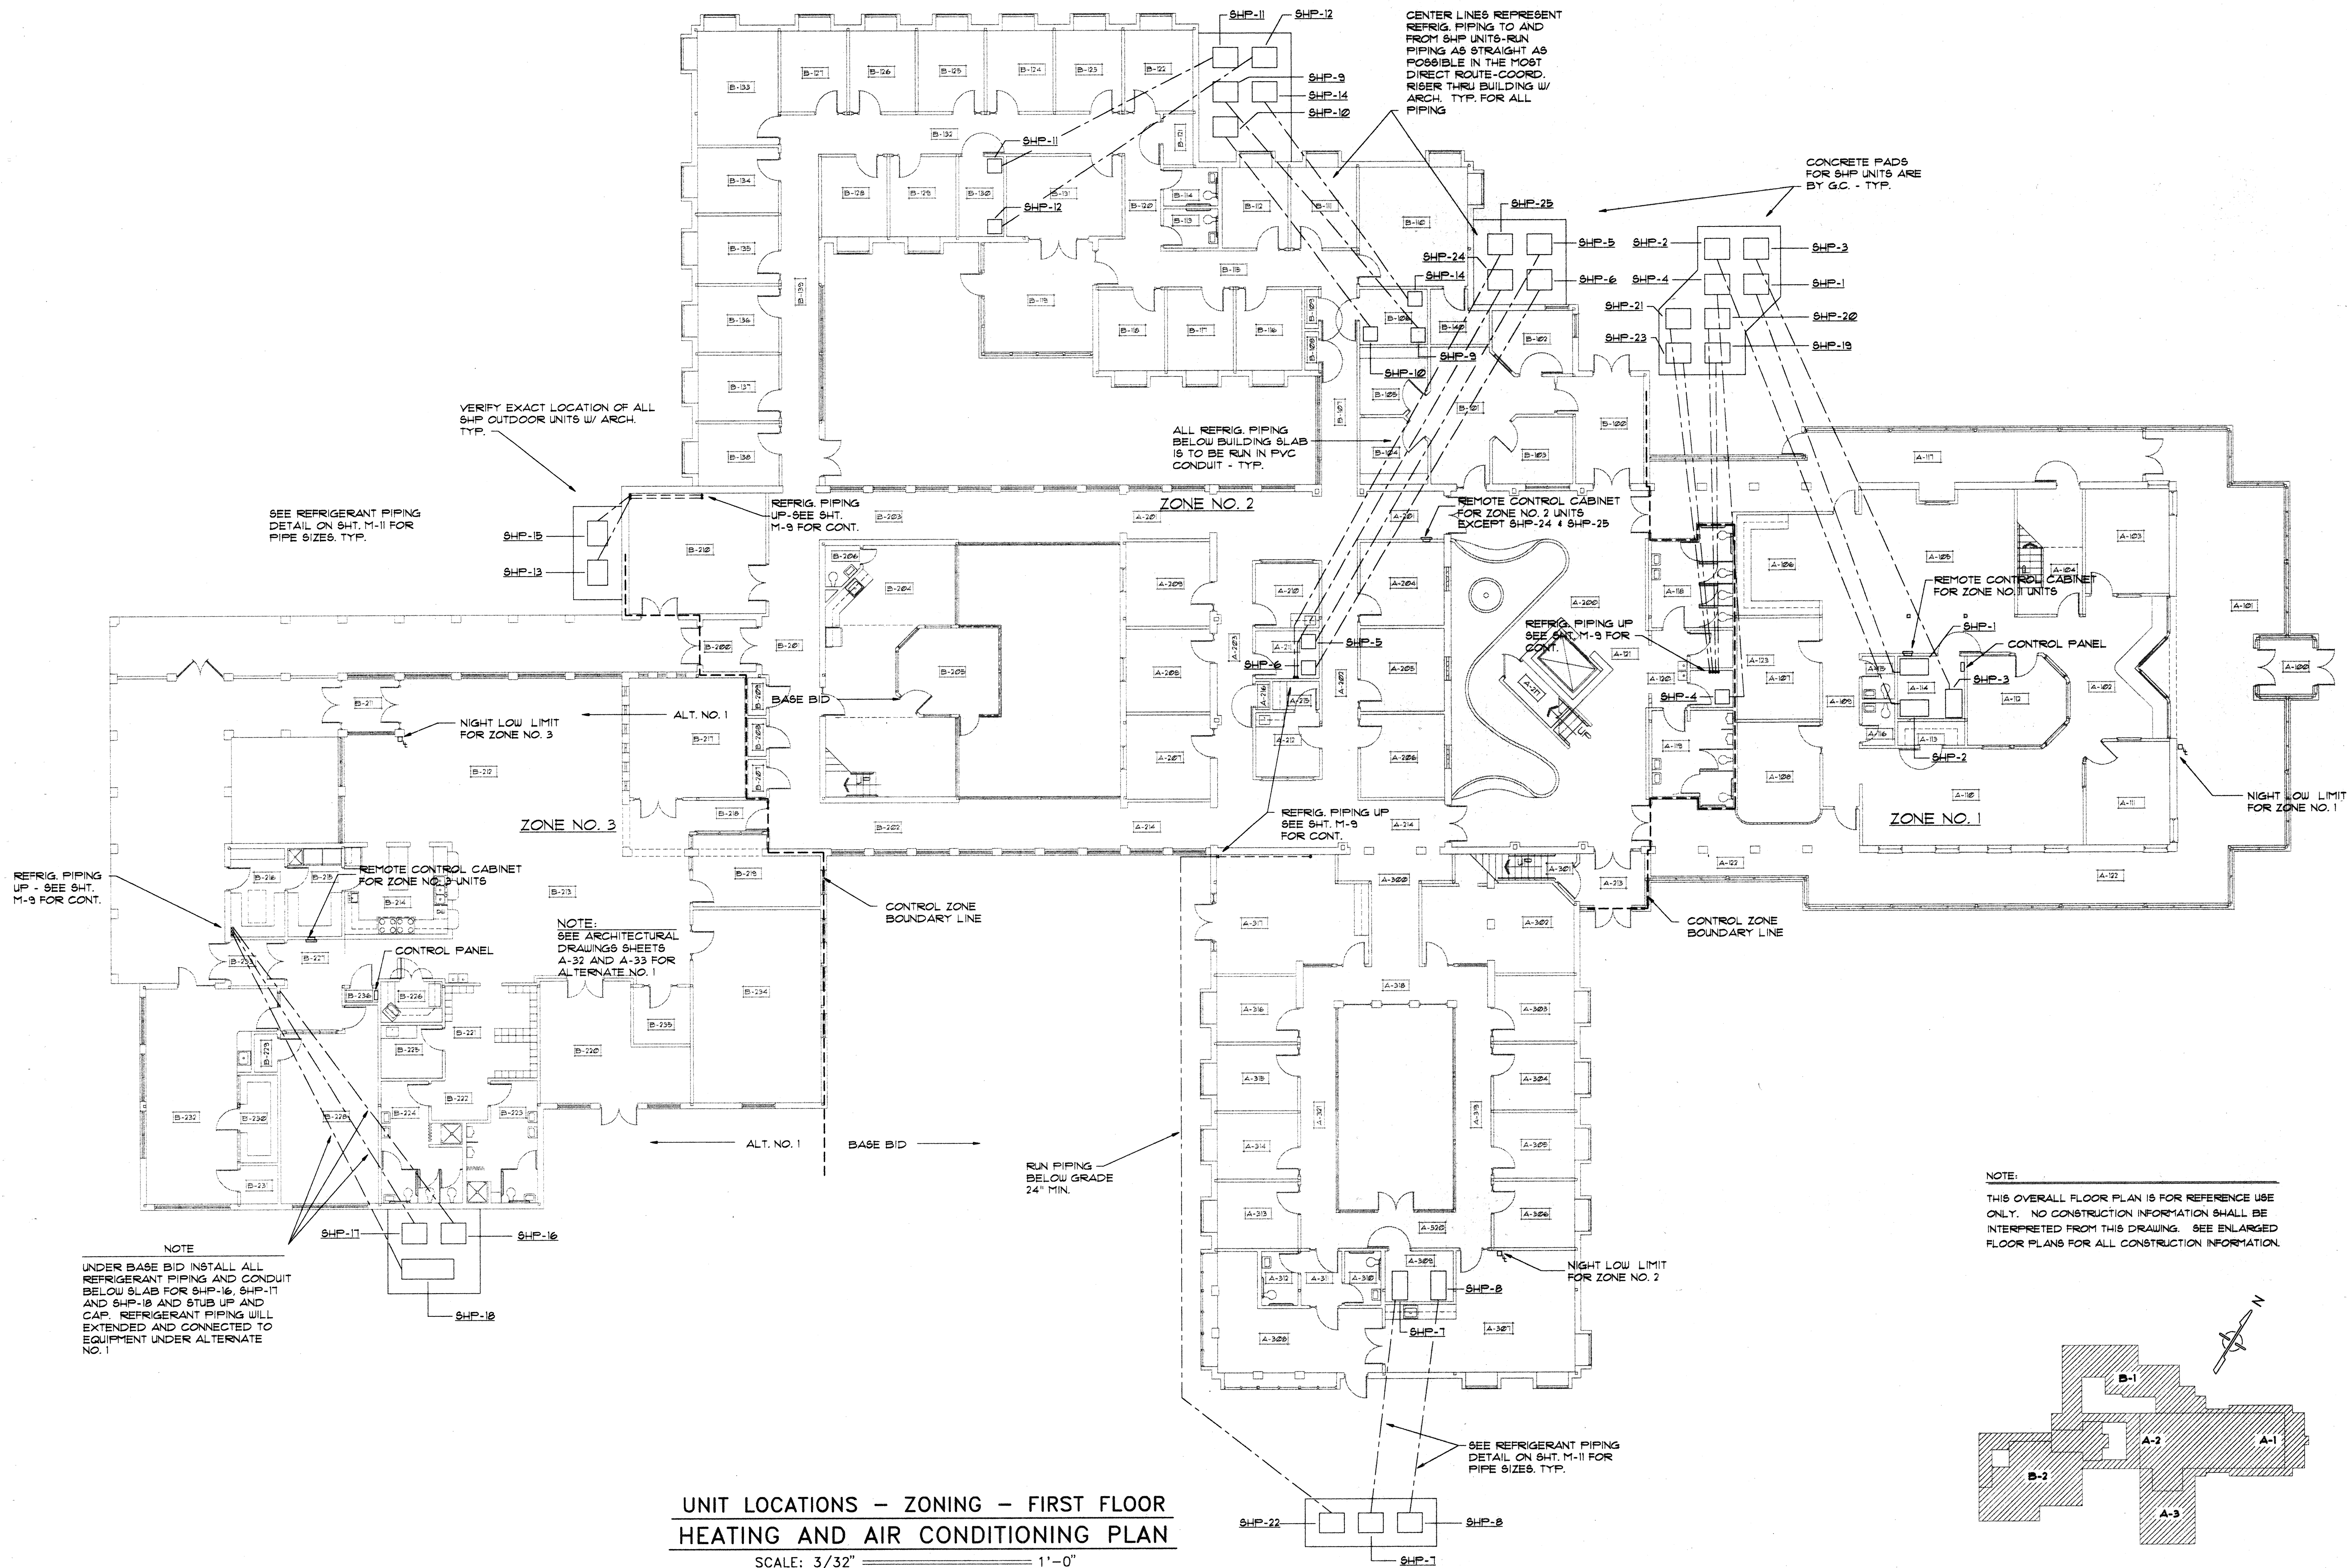

UNIT LOCATIONS - ZONING - FIRST FLOOR  
HEATING AND AIR CONDITIONING PLAN

SCALE: 3/32" = 1'-0"



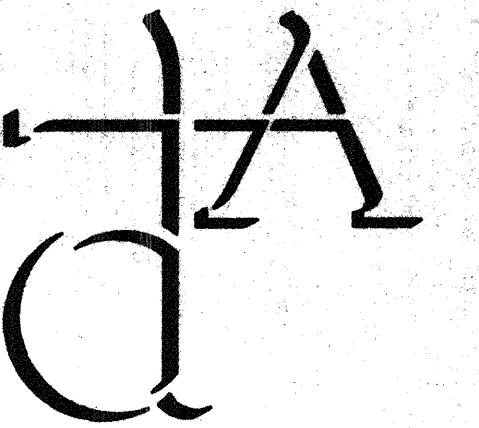

Drakeford Architects

120 North Main Street  
Sumter SC 29150 803 775-8587

Date April 93

Revisions

Waccamaw  
CMHS Central  
Facility

Horry County, S.C.


Project No. J12-9544-PM

Heating and Air  
Conditioning

Unit Locations -  
Zoning


Second Floor Plan

Scale: 3/32" = 1'-0"

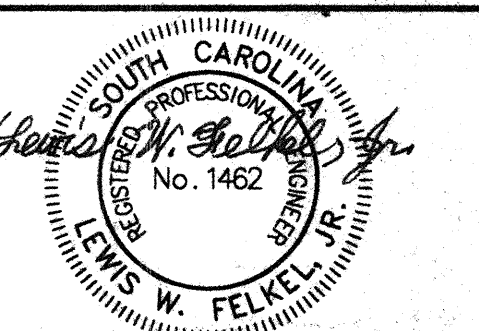

FELKEL & HASTINGS  
Mechanical Engineers  
2740 Devine Street  
Columbia, S.C. 29205  
Comm. No.: 1494 Date: 3-29-93

Sheet M-9 of 11

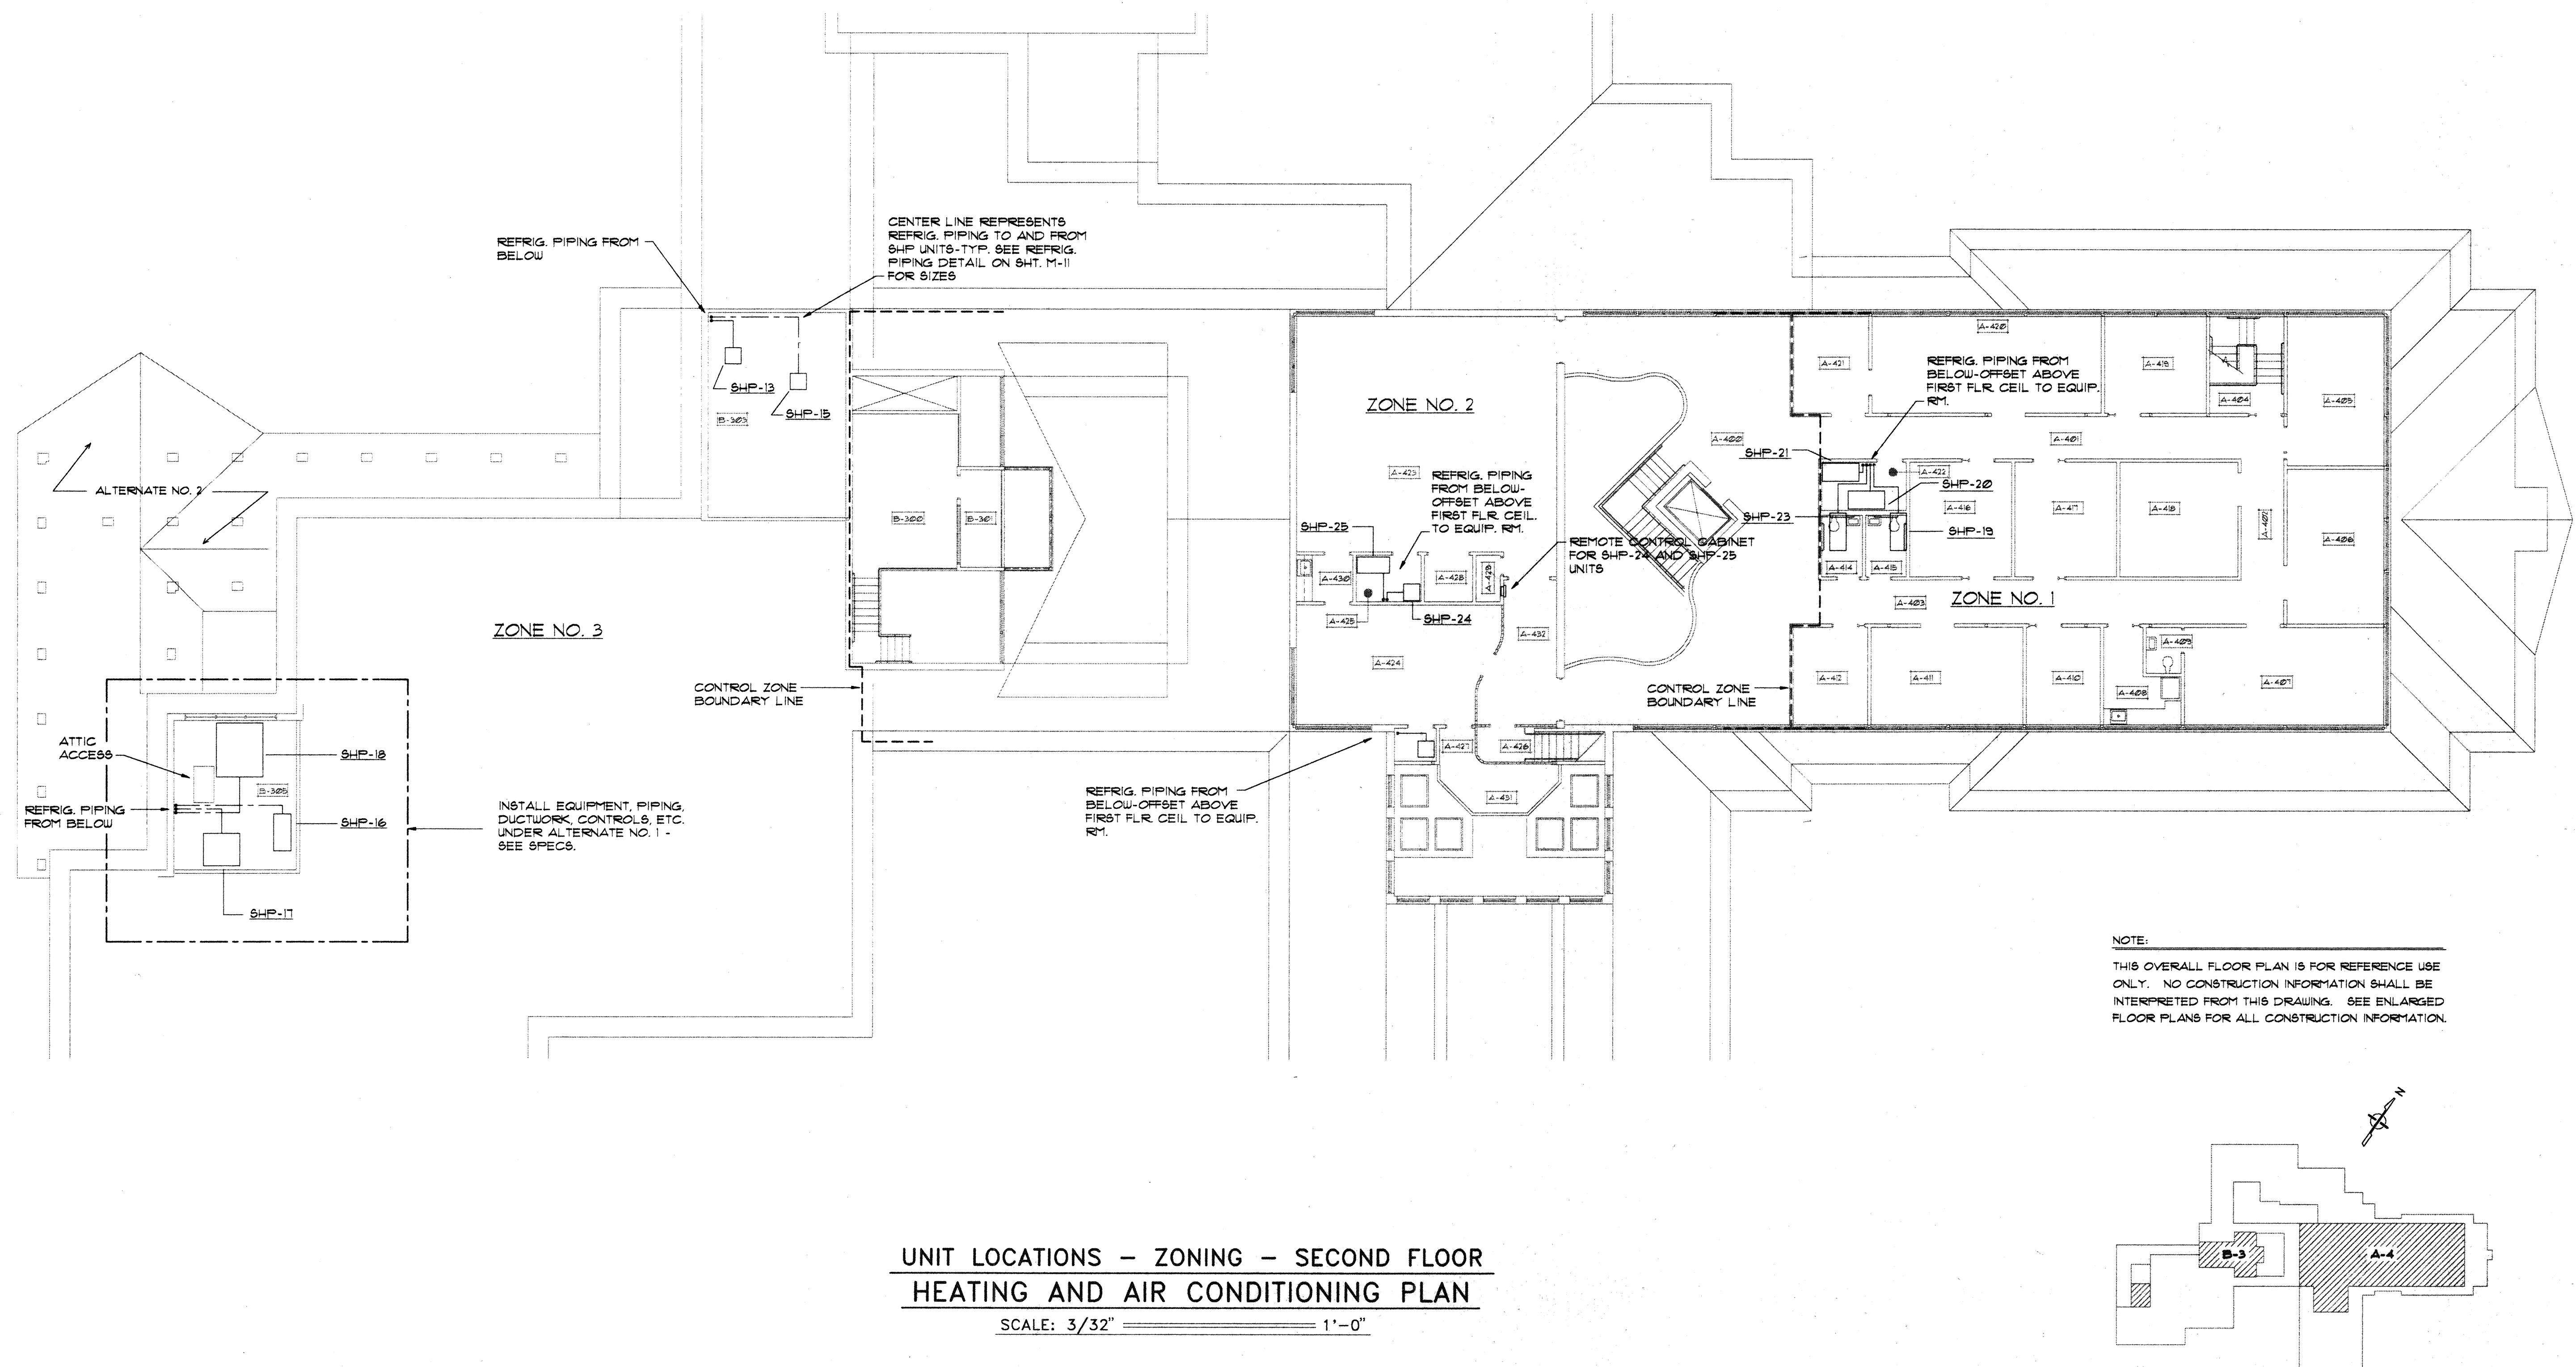

UNIT LOCATIONS - ZONING - SECOND FLOOR  
HEATING AND AIR CONDITIONING PLAN

SCALE: 3/32" = 1'-0"



## SPLIT SYSTEM HEAT PUMP SCHEDULE

| SYMBOL   | MFGR  | INDOOR UNIT DATA |        |           |                 |          |                      |                            | OUTDOOR UNIT DATA |          |           |             |          | COOLING CAPACITY         |          | HEATING CAPACITY |               |                           | TOTAL HEATING CAPACITY<br>M. B. H. | REMARKS |                        |                      |
|----------|-------|------------------|--------|-----------|-----------------|----------|----------------------|----------------------------|-------------------|----------|-----------|-------------|----------|--------------------------|----------|------------------|---------------|---------------------------|------------------------------------|---------|------------------------|----------------------|
|          |       | MODEL NO.        | TYPE   | NOM. CFM. | EXT. ST. PRESS. | FAN H.P. | BLOWER MOTOR CURRENT | ELECT. SUP. HEATER SECTION |                   |          | MODEL NO. | TYPE DISCH. | FAN H.P. | TOTAL POWER INPUT - K.W. | CURRENT  | M. B. H.         | AMBIENT TEMP. | 1st STAGE HEAT PUMP CYCLE |                                    |         | 2nd STAGE SUPPLEMENTAL |                      |
|          |       |                  |        |           |                 |          |                      | K.W.                       | NO. OF CIRCUITS   | CURRENT  |           |             |          |                          |          |                  |               | M. B. H.                  |                                    |         | OUTDOOR AMB. TEMP.     | ELECT. HEAT M. B. H. |
| SHP - 1  | TRANE | TUE030A          | VERT.  | 3000      | 55"             | 15       | 460-3-60             | 14.96                      | ONE               | 460-3-60 | TWA030A   | VERT.       | 50       | 851                      | 460-3-60 | 900              | 95° F.        | 45.0                      | 11° F.                             | 51.0    | 96.0                   |                      |
| SHP - 2  | TRANE | TUE030A          | VERT.  | 3000      | 55"             | 15       | 460-3-60             | 14.96                      | ONE               | 460-3-60 | TWA030A   | VERT.       | 50       | 851                      | 460-3-60 | 900              | 95° F.        | 45.0                      | 11° F.                             | 51.0    | 96.0                   |                      |
| SHP - 3  | TRANE | TUE030A          | VERT.  | 2400      | 50"             | 15       | 460-3-60             | 9.96                       | ONE               | 460-3-60 | TWA072A   | VERT.       | 33       | 788                      | 460-3-60 | 705              | 95° F.        | 36.4                      | 11° F.                             | 34.0    | 70.4                   |                      |
| SHP - 4  | TRANE | TUV042A          | VERT.  | 1400      | 45"             | 33       | 208-1-60             | 6.5                        | ONE               | 208-1-60 | TWA042A   | VERT.       | 25       | 456                      | 460-3-60 | 410              | 95° F.        | 25.0                      | 11° F.                             | 22.2    | 47.2                   |                      |
| SHP - 5  | TRANE | TUV048A          | VERT.  | 1500      | 45"             | 50       | 208-1-60             | 6.5                        | ONE               | 208-1-60 | TWA048A   | VERT.       | 25       | 525                      | 460-3-60 | 46.0             | 95° F.        | 27.2                      | 11° F.                             | 22.2    | 49.4                   |                      |
| SHP - 6  | TRANE | TUV036B          | VERT.  | 1300      | 40"             | 50       | 208-1-60             | 3.6                        | ONE               | 208-1-60 | TWA036A   | VERT.       | 20       | 401                      | 460-3-60 | 36.4             | 95° F.        | 20.2                      | 11° F.                             | 12.3    | 32.5                   |                      |
| SHP - 7  | TRANE | TUE030A          | VERT.  | 3000      | 55"             | 15       | 460-3-60             | 14.96                      | ONE               | 460-3-60 | TWA030A   | VERT.       | 50       | 851                      | 460-3-60 | 900              | 95° F.        | 45.0                      | 11° F.                             | 51.0    | 96.0                   |                      |
| SHP - 8  | TRANE | TUE030A          | VERT.  | 3000      | 55"             | 15       | 460-3-60             | 14.96                      | ONE               | 460-3-60 | TWA030A   | VERT.       | 50       | 851                      | 460-3-60 | 900              | 95° F.        | 45.0                      | 11° F.                             | 51.0    | 96.0                   |                      |
| SHP - 9  | TRANE | TUV036B          | VERT.  | 1200      | 40"             | 50       | 208-1-60             | 3.6                        | ONE               | 208-1-60 | TWA036A   | VERT.       | 20       | 401                      | 460-3-60 | 36.4             | 95° F.        | 20.2                      | 11° F.                             | 12.3    | 32.5                   |                      |
| SHP - 10 | TRANE | TUV064P          | VERT.  | 2000      | 45"             | 50       | 208-1-60             | 10.8                       | ONE               | 208-1-60 | TWA060A   | VERT.       | 50       | 6.93                     | 460-3-60 | 61.0             | 95° F.        | 36.0                      | 11° F.                             | 36.8    | 72.8                   |                      |
| SHP - 11 | TRANE | TUV064P          | VERT.  | 2000      | 45"             | 50       | 208-1-60             | 10.8                       | ONE               | 208-1-60 | TWA060A   | VERT.       | 50       | 6.93                     | 460-3-60 | 61.0             | 95° F.        | 36.0                      | 11° F.                             | 36.8    | 72.8                   |                      |
| SHP - 12 | TRANE | TUV048A          | VERT.  | 1600      | 45"             | 50       | 208-1-60             | 6.5                        | ONE               | 208-1-60 | TWA048A   | VERT.       | 25       | 525                      | 460-3-60 | 46.0             | 95° F.        | 27.2                      | 11° F.                             | 22.2    | 49.4                   |                      |
| SHP - 13 | TRANE | TUV064P          | VERT.  | 2000      | 45"             | 50       | 208-1-60             | 10.8                       | ONE               | 208-1-60 | TWA060A   | VERT.       | 50       | 6.93                     | 460-3-60 | 61.0             | 95° F.        | 36.0                      | 11° F.                             | 36.8    | 72.8                   |                      |
| SHP - 14 | TRANE | TUV042A          | VERT.  | 1400      | 45"             | 33       | 208-1-60             | 6.5                        | ONE               | 208-1-60 | TWA042A   | VERT.       | 25       | 456                      | 460-3-60 | 410              | 95° F.        | 25.0                      | 11° F.                             | 22.2    | 47.2                   |                      |
| SHP - 15 | TRANE | TUV048A          | VERT.  | 1650      | 45"             | 50       | 208-1-60             | 6.5                        | ONE               | 208-1-60 | TWA048A   | VERT.       | 25       | 525                      | 460-3-60 | 46.0             | 95° F.        | 27.2                      | 11° F.                             | 22.2    | 49.4                   |                      |
| SHP - 16 | TRANE | TUV064P          | VERT.  | 2000      | 45"             | 50       | 208-1-60             | 10.8                       | ONE               | 208-1-60 | TWA060A   | VERT.       | 50       | 6.93                     | 460-3-60 | 61.0             | 95° F.        | 36.0                      | 11° F.                             | 36.8    | 72.8                   |                      |
| SHP - 17 | TRANE | TUE030A          | VERT.  | 2400      | 50"             | 15       | 460-3-60             | 9.96                       | ONE               | 460-3-60 | TWA072A   | VERT.       | 33       | 788                      | 460-3-60 | 705              | 95° F.        | 36.4                      | 11° F.                             | 34.0    | 70.4                   |                      |
| SHP - 18 | TRANE | TUE180           | HORIZ. | 6000      | 50"             | 20       | 460-3-60             | 19.92                      | ONE               | 460-3-60 | TWA180B   | VERT.       | 2750     | 1160                     | 460-3-60 | 180.0            | 95° F.        | 90.0                      | 11° F.                             | 67.9    | 157.9                  |                      |
| SHP - 19 | TRANE | TUH030B          | HORIZ. | 1000      | 40"             | 33       | 208-1-60             | 3.6                        | ONE               | 208-1-60 | TWA030A   | VERT.       | 125      | 3.23                     | 460-3-60 | 29.6             | 95° F.        | 16.1                      | 11° F.                             | 12.3    | 28.4                   |                      |
| SHP - 20 | TRANE | TUE030A          | VERT.  | 3000      | 55"             | 15       | 460-3-60             | 14.96                      | ONE               | 460-3-60 | TWA030A   | VERT.       | 50       | 851                      | 460-3-60 | 900              | 95° F.        | 45.0                      | 11° F.                             | 51.0    | 96.0                   |                      |
| SHP - 21 | TRANE | TUE030A          | VERT.  | 3000      | 55"             | 15       | 460-3-60             | 14.96                      | ONE               | 460-3-60 | TWA030A   | VERT.       | 50       | 851                      | 460-3-60 | 900              | 95° F.        | 45.0                      | 11° F.                             | 51.0    | 96.0                   |                      |
| SHP - 22 | TRANE | TUV036B          | VERT.  | 1200      | 40"             | 50       | 208-1-60             | 3.6                        | ONE               | 208-1-60 | TWA036A   | VERT.       | 20       | 401                      | 460-3-60 | 36.4             | 95° F.        | 20.2                      | 11° F.                             | 12.3    | 32.5                   |                      |
| SHP - 23 | TRANE | TUH064F          | HORIZ. | 2000      | 45"             | 50       | 208-1-60             | 10.8                       | ONE               | 208-1-60 | TWA060A   | VERT.       | 50       | 6.93                     | 460-3-60 | 61.0             | 95° F.        | 36.0                      | 11° F.                             | 36.8    | 72.8                   |                      |
| SHP - 24 | TRANE | TUV042A          | VERT.  | 1400      | 45"             | 33       | 208-1-60             | 6.5                        | ONE               | 208-1-60 | TWA042A   | VERT.       | 25       | 456                      | 460-3-60 | 410              | 95° F.        | 25.0                      | 11° F.                             | 22.2    | 47.2                   |                      |
| SHP - 25 | TRANE | TUE030A          | VERT.  | 3000      | 55"             | 15       | 460-3-60             | 14.96                      | ONE               | 460-3-60 | TWA030A   | VERT.       | 50       | 851                      | 460-3-60 | 900              | 95° F.        | 45.0                      | 11° F.                             | 51.0    | 96.0                   |                      |
|          |       |          |       
NOTE: FURNISH RETURN AIR PLENUM BASES FOR INDOOR UNITS AS NECESSARY

## VENTILATING EQUIPMENT SCHEDULE

[illegible]

## AIR DISTRIBUTION SCHEDULE

| SYMBOL | TYPE SERVICE                 | MFGR       | MODEL NO. | TYPE FINISH | ACCESSORIES | REMARKS                             |
|--------|------------------------------|------------|-----------|-------------|-------------|-------------------------------------|
| TF     | "THERMA-FUSER"               | ACUTHERM   | TF - HC   | OFF - WHITE | -----       | VAV COOLING & HEATING               |
| SCS    | SURFACE CEILING SUPPLY       | METAL-AIRE | 1000 - 1  | OFF - WHITE | OBD         |                                     |
| SCR    | SURFACE CEILING RETURN       | "          | 1000R - 1 | OFF - WHITE | -----       |                                     |
| SWS    | SIDEWALL SUPPLY REGISTER     | "          | 42C       | *           | OBD         |                                     |
| SWR    | SIDEWALL RETURN GRILLE       | "          | 41C       | *           | -----       |                                     |
| SG     | SOFFIT INTAKE GRILLE         | "          | 41C       | *           | -----       |                                     |
| SEG    | SOFFIT EXHAUST GRILLE        | "          | 41C       | *           | -----       |                                     |
| LSD    | LINEAR SLOT DIFFUSER         | "          | 6100      | QWB         | BPI PLENUM  | TYPE 12 9M, 18" X 8 SLOT, 2 EC, FCD |
| SWS-DD | SIDEWALL SUP. DOUB. DEFLECT. | "          | V4004     | OFF-WHITE   | OBD         |                                     |
| SECG   | SURF. EGG-CRATE GRILLE       | "          | CC5       | "           | -----       |                                     |
| CSD    | CEILING SUPPLY DIFFUSER      | "          | H4004     | "           | OBD         |                                     |
|        |                              |            |           |             |             |                                     |
|        |                              |            |           |             |             |                                     |

\* COLOR SELECTED BY ARCHITECT



Drakeford Architects

120 North Main Street  
Sumter SC 29150 803 775-6567

Date April 93

## Revisions


Waccamaw  
CMHS Central  
Facility

Horry County, S.C.

Project No. J12-9544-PM

## Heating and Air Conditioning Schedules


Scale: None

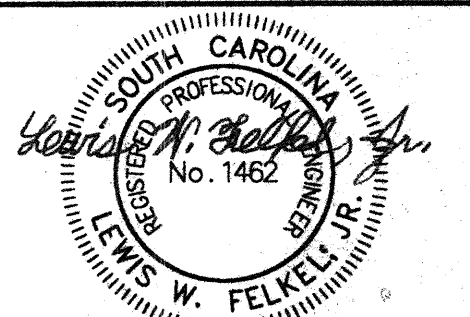


**FELKEL & HASTINGS**  
Mechanical Engineers  
2740 Devine Street  
Columbia, S.C. 29205  
Comm. No.: 1494 Date: 3-29-93

Sheet M-10 of 11



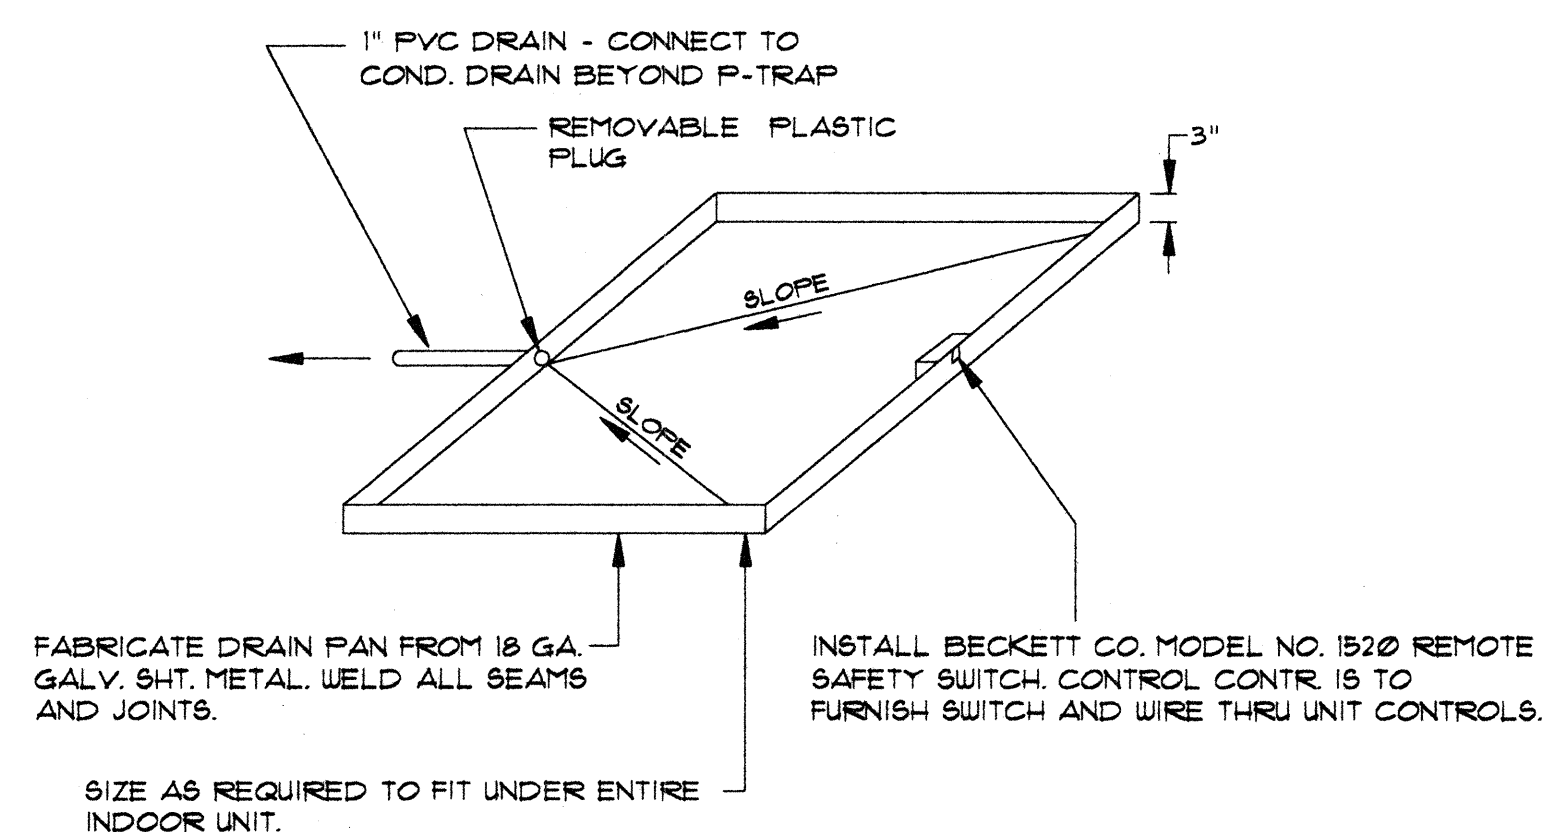

**AUXILIARY DRAIN PAN DETAIL**  
(PROVIDE DRAIN PANS FOR HORIZONTAL SHP-19 & SHP-23 INDOOR UNITS)

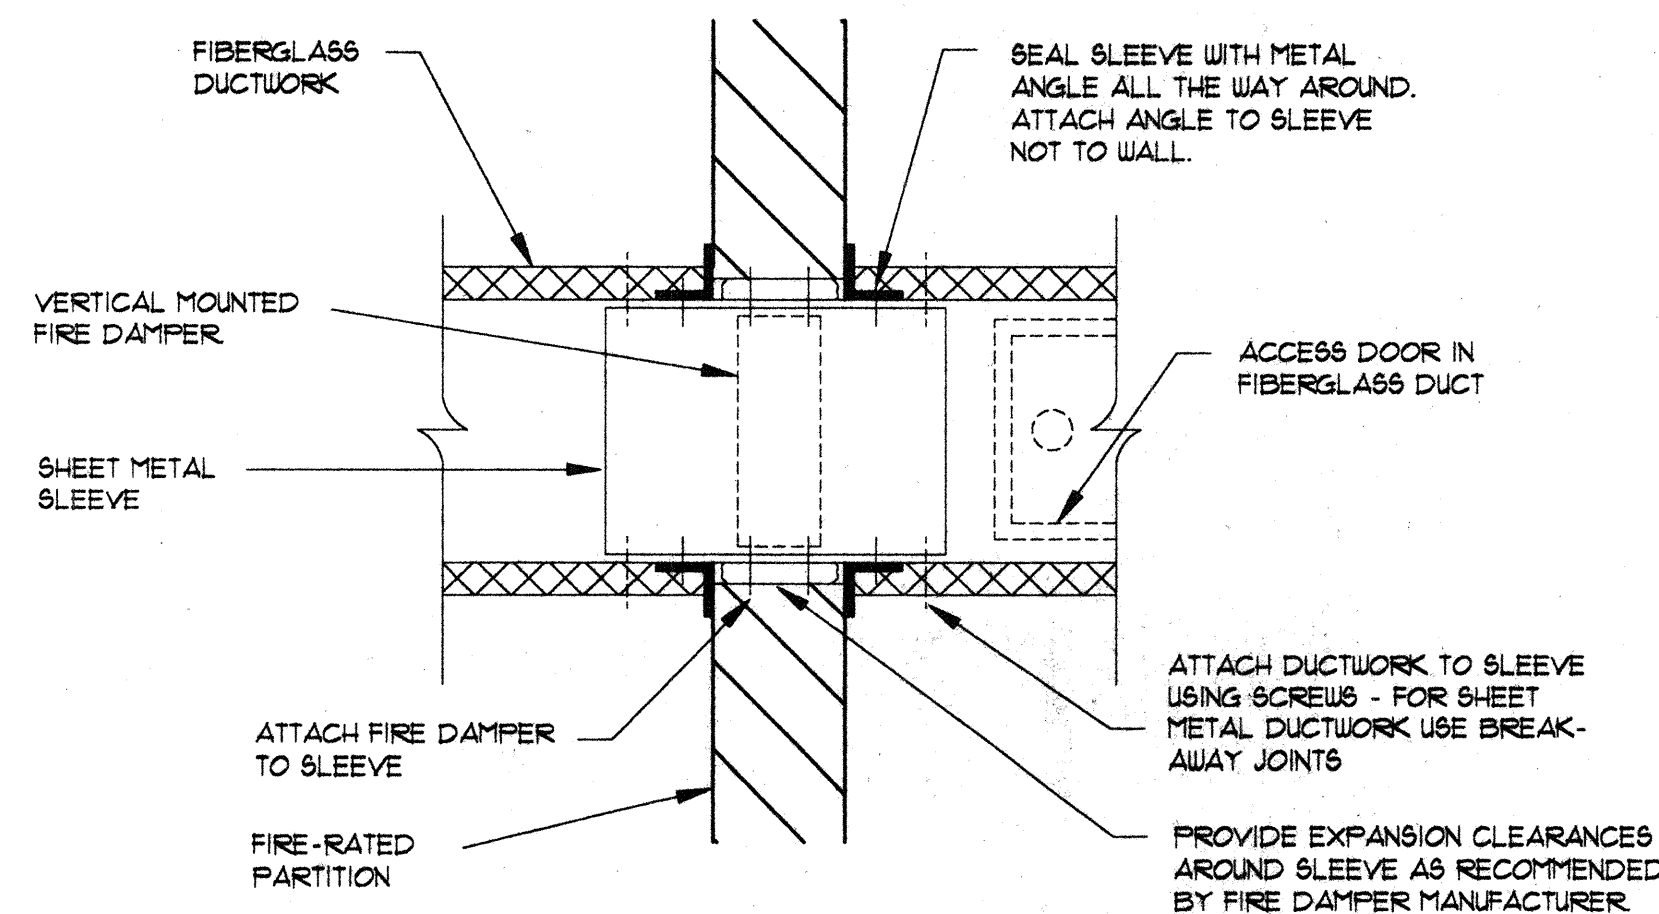


**FIRE PARTITION PENETRATION DETAIL**  
(INSTALLATION OF HORIZONTAL FIRE DAMPER IS SIMILAR)

**LEGEND**

- A. D. — CEILING OR WALL ACCESS DOOR
- S — SWITCH FURNISHED BY MECH. CONTR.
- T — THERMOSTAT FURN. BY MECH. CONTR.
- ⬆ V — VERTICAL MOUNTED FIRE DAMPER
- ⬆ H — HORIZONTAL MOUNTED FIRE DAMPER
- RL — REFRIGERANT LIQUID
- RV — REFRIGERANT VAPOR
- D. — CONDENSATE DRAIN
- F. D. — FLOOR DRAIN BY PLMB. CONTR.
- R — REFRIGERANT PIPING - RL/RV
- RS — REMOTE SENSOR

**NOTES**

1. VERIFY ALL PIPE SIZES W/ UNIT MFG. BEFORE INSTALLATION.
2. INSTALL ALL PIPING, FITTINGS AND ACCESSORIES IN STRICT ACCORDANCE WITH UNIT MFG'S RECOMMENDATIONS.
3. INSTALL FILTER DRIER IN REFRIGERANT LIQUID LINE W/ ALL NECESSARY CHECK VALVES AND FITTINGS IF DRIER IS NOT INSTALLED IN EITHER THE INDOOR OR OUTDOOR UNITS.

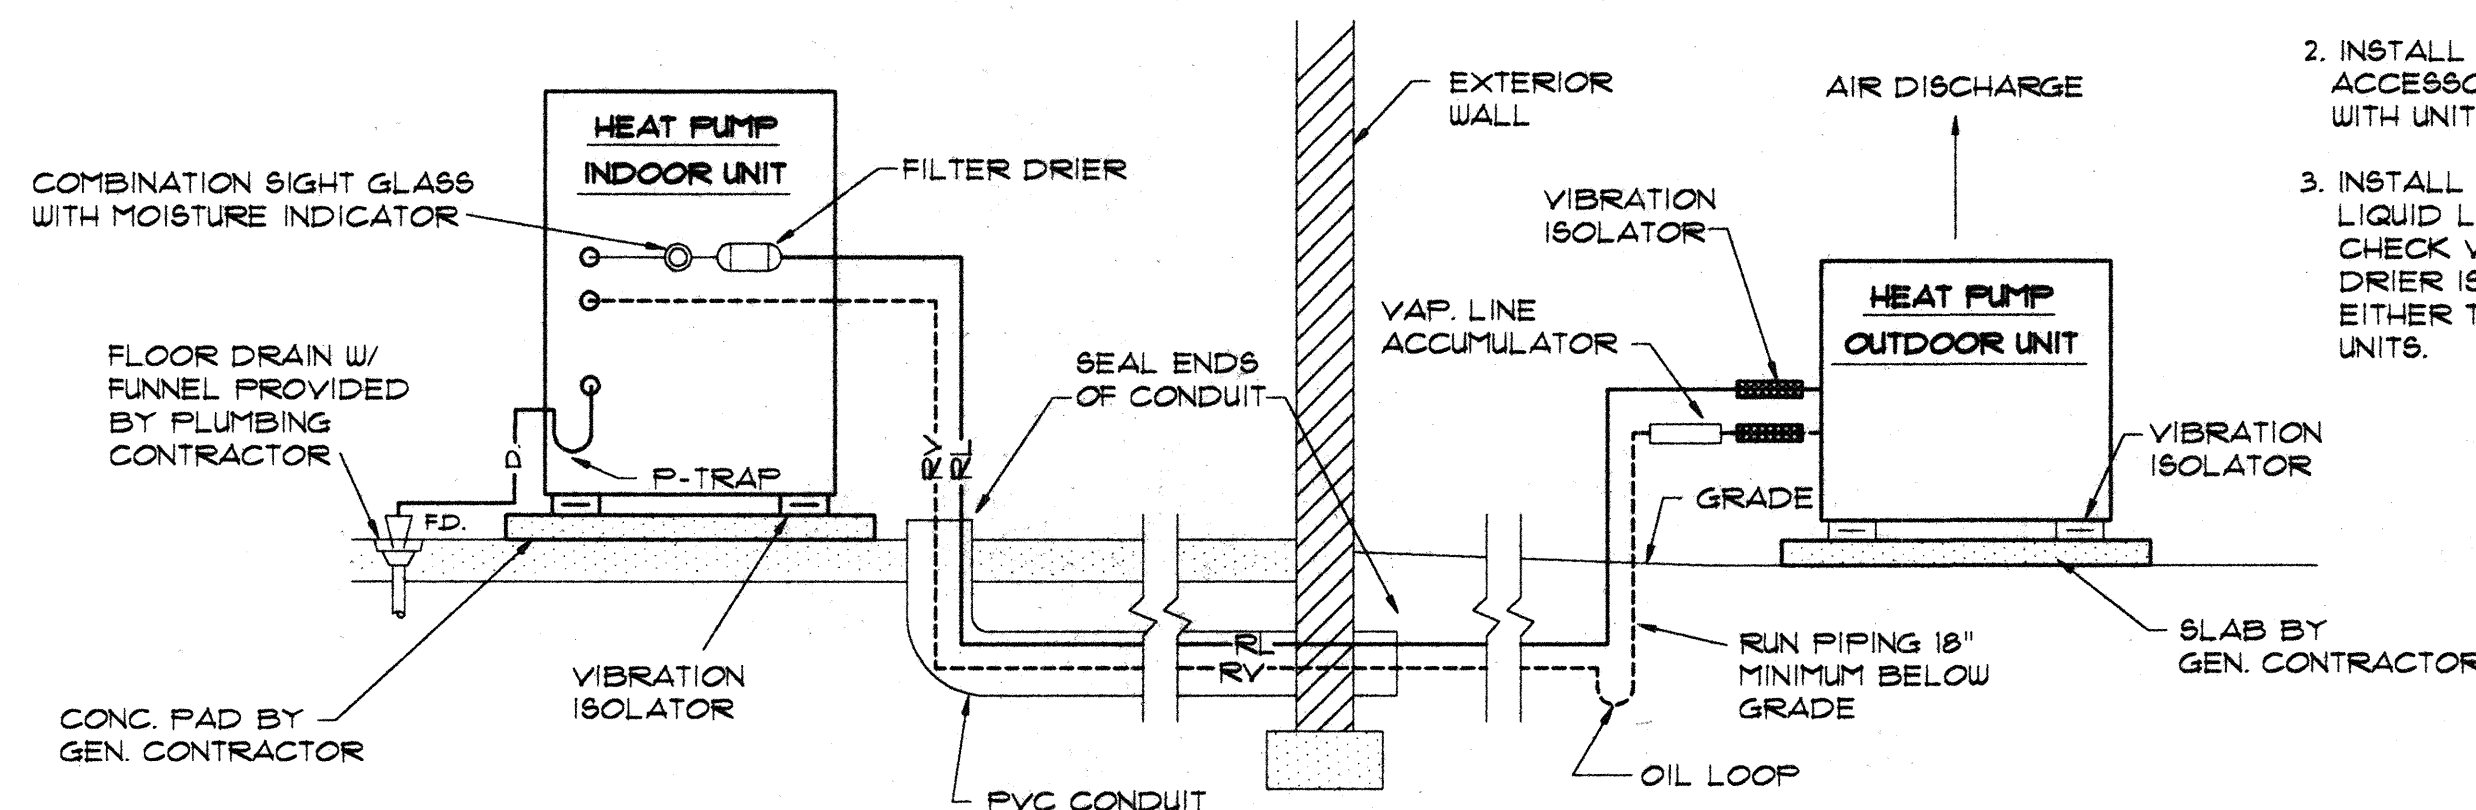

**REFRIGERANT PIPING DETAIL**

**PIPE SIZING SCHEDULE \***

| SYMBOL | RL-REFRIG. LIQUID | RV-REFRIG. VAPOR | D-CONDENSATE DRAIN | REMARKS             |
|--------|-------------------|------------------|--------------------|---------------------|
| SHP-1  | 1/2"              | 1-1/8"           | 1-1/4"             |                     |
| SHP-2  | 1/2"              | 1-1/8"           | 1-1/4"             |                     |
| SHP-3  | 1/2"              | 1-1/8"           | 1-1/4"             |                     |
| SHP-4  | 1/2"              | 1/8"             | 1"                 |                     |
| SHP-5  | 1/2"              | 1-1/8"           | 1"                 |                     |
| SHP-6  | 1/2"              | 1/8"             | 1"                 |                     |
| SHP-7  | 1/2"              | 1-1/8"           | 1-1/4"             |                     |
| SHP-8  | 1/2"              | 1-1/8"           | 1-1/4"             |                     |
| SHP-9  | 1/2"              | 1/8"             | 1"                 |                     |
| SHP-10 | 1/2"              | 1-1/8"           | 1"                 |                     |
| SHP-11 | 1/2"              | 1-1/8"           | 1"                 |                     |
| SHP-12 | 1/2"              | 1-1/8"           | 1"                 |                     |
| SHP-13 | 1/2"              | 1-1/8"           | 1"                 |                     |
| SHP-14 | 1/2"              | 1/8"             | 1"                 |                     |
| SHP-15 | 1/2"              | 1-1/8"           | 1"                 |                     |
| SHP-16 | 1/2"              | 1-1/8"           | 1"                 |                     |
| SHP-17 | 1/2"              | 1-1/8"           | 1-1/4"             |                     |
| SHP-18 | 1/2"              | 1-1/8"           | 1-1/4"             |                     |
| SHP-19 | 1/2"              | 1/8"             | 1"                 | REQUIRES 2 CIRCUITS |
| SHP-20 | 1/2"              | 1-1/8"           | 1-1/4"             |                     |
| SHP-21 | 1/2"              | 1-1/8"           | 1-1/4"             |                     |
| SHP-22 | 1/2"              | 1/8"             | 1"                 |                     |
| SHP-23 | 1/2"              | 1-1/8"           | 1"                 |                     |
| SHP-24 | 1/2"              | 1/8"             | 1"                 |                     |
| SHP-25 | 1/2"              | 1-1/8"           | 1-1/4"             |                     |

\* DUE TO EXCESSIVE REFRIGERANT LINE LENGTHS, SIZES SHOWN ARE FOR BIDDING PURPOSES ONLY. VERIFY EXACT SIZES WITH UNIT MANUFACTURER BEFORE INSTALLING ANY PIPING.



Drakeford Architects

120 North Main Street  
Sumter SC 29150 803 775-6567

Date April 93

Revisions

Waccamaw  
CMHS Central  
Facility


Horry County, S.C.

Project No. J12-9544-PM

Heating and Air  
Conditioning

Schedules and  
Details

Scale: 3/16" = 1'0"

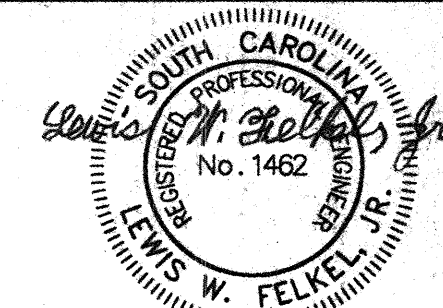

FELKEL & HASTINGS  
Mechanical Engineers  
2740 Devine Street  
Columbia, S.C. 29205  
Comm. No.: 1494 Date: 3-29-93

Sheet M-11 of 11